

File name: C:\Users\Datatony\OneDrive - Harvard Jolly, Inc\22046.00_SJSD K-8 School COGS CAD\Sheet\3042\T1 Plot Date: 11-30-2022 Plotted By: Datatony Sorawadskul

ARCHITECTURAL MATERIALS SYMBOL LEGEND			
	EARTH		SOLID PANEL FOLDING PARTITION OR OPERABLE WALL
	CONCRETE		WIRE FENCE OR PARTITION
	METAL (IN SECTION)		REINFORCING BARS
	5" STUD WALL (U.O.N.)		METAL DECK
	CONCRETE TILT-WALL (IF APPLICABLE)		RIGID INSULATION
	CONCRETE MASONRY WALL (IF APPLICABLE)		BATT INSULATION
	CONCRETE MASONRY UNIT (CORED IN SECTION)		PLYWOOD
			ACOUSTICAL CEILING TILE

ARCHITECTURAL DRAWING SYMBOLS LEGEND			
901	ROOM NUMBER		VERTICAL ELEVATION DATA
W1	WALL TYPE		DETAIL REFERENCE
101	DOOR NUMBER		REVISION CLOUD (current revision)
X	WINDOW TYPE		SECTION TAG
X	LOUVER TYPE		DETAIL TITLE
E100	EQUIPMENT TYPE		DETAIL/ DRAWING TITLE
E100	ELEVATION MARK		
	NORTH ARROW		

INDEX OF DRAWINGS

VOLUME ONE					VOLUME ONE (CONT.)					VOLUME ONE (CONT.)					VOLUME TWO					VOLUME TWO (CONT.)					VOLUME TWO (CONT.)				
SHEET NO.	SHEET TITLE	ORIGINAL DATE	REV. NO.	REVISION DATE	SHEET NO.	SHEET TITLE	ORIGINAL DATE	REV. NO.	REVISION DATE	SHEET NO.	SHEET TITLE	ORIGINAL DATE	REV. NO.	REVISION DATE	SHEET NO.	SHEET TITLE	ORIGINAL DATE	REV. NO.	REVISION DATE	SHEET NO.	SHEET TITLE	ORIGINAL DATE	REV. NO.	REVISION DATE	SHEET NO.	SHEET TITLE	ORIGINAL DATE	REV. NO.	REVISION DATE
COV.1	COVER SHEET	10-21-22			LS1.3	ARCHITECTURAL (CONTINUED)	10-21-22	1	11-16-22	AB.7	ARCHITECTURAL (CONTINUED)	10-21-22	2	11-21-22	COV.2	COVER SHEET	10-21-22			PI.2	PLUMBING (CONTINUED)	10-21-22			E4.5	ELECTRICAL (CONTINUED)	10-21-22		
T1	INDEX / ABBREV. / SYMBOLS / MATERIALS	10-21-22	3	11-28-22	LS1.4	PARTIAL FIRST FLOOR LIFE SAFETY PLAN - AREA 800	10-21-22	1	11-16-22	AB.8	PARTIAL SECOND FLOOR CEILING PLAN - AREA 400	10-21-22	2	11-21-22	T2	INDEX / ABBREV. / SYMBOLS / MATERIALS	10-21-22	3	11-28-22	PI.3	FIRST FLOOR AREA 200 SANITARY PLAN	10-21-22			E4.6	AREA 700 ENLARGED ELECTRICAL AND DATA ROOM	10-21-22	1	11-16-22
					LS1.5	PARTIAL FIRST FLOOR LIFE SAFETY PLAN - AREA 700	10-21-22	1	11-16-22	AB.9	PARTIAL SECOND FLOOR CEILING PLAN - AREA 800	10-21-22	2	11-21-22					PI.4	FIRST FLOOR AREA 300 SANITARY PLAN	10-21-22			E4.7	AREA 800 ENLARGED ELECTRICAL AND DATA ROOM	10-21-22			
					LS1.6	PARTIAL SECOND FLOOR LIFE SAFETY PLAN - AREA 400 & 500	10-21-22	1	11-16-22	AB.10	PARTIAL THIRD FLOOR CEILING PLAN - AREA 1000	10-21-22	2	11-21-22					PI.5	FIRST FLOOR AREA 700 SANITARY PLAN	10-21-22			E4.8	AREA 500 & 800 ENLARGED ELECTRICAL AND DATA ROOMS	10-21-22			
C01	COVER SHEET	10-21-22			LS1.7	PARTIAL SECOND FLOOR LIFE SAFETY PLAN - AREA 800	10-21-22	1	11-16-22	A10.1	ELEVATOR DETAILS	10-21-22			M0.1	MECHANICAL	10-21-22			PI.6	BLDG 4 AND 5 SANITARY PLAN	10-21-22			E4.9	AREA 900 & 1000 ENLARGED ELECTRICAL AND DATA ROOMS	10-21-22		
C02	MOG GENERAL NOTES	10-21-22	1	11-16-22	LS1.8	PARTIAL THIRD FLOOR LIFE SAFETY PLAN - AREA 800 & 1000	10-21-22	1	11-16-22	A10.2	STAR DETAILS	10-21-22	2	11-21-22	M0.2	LEGEND AND GENERAL NOTES	10-21-22			PI.7	FIRST FLOOR AREA 100 WATER PLAN	10-21-22	1	11-16-22	E5.1	POWER ONE - LINE DIAGRAM	10-21-22		
C03	GENERAL UTILITY NOTES	10-21-22	1	11-16-22	A0.1	OVERALL BUILDING FIRST AND SECOND FLOOR PLANS	10-21-22			A10.3	STAR DETAILS	10-21-22			M0.3	MECHANICAL SCHEDULES	10-21-22			PI.8	FIRST FLOOR AREA 200 WATER PLAN	10-21-22	1	11-16-22	E5.2	POWER RISER DIAGRAM	10-21-22		
C04	SURVEY	10-21-22			A0.2	OVERALL BUILDING THIRD FLOOR PLAN	10-21-22			A10.4	STAR DETAILS	10-21-22			M0.4	MECHANICAL SCHEDULES	10-21-22			PI.9	FIRST FLOOR AREA 300 WATER PLAN	10-21-22	1	11-16-22	E5.3	POWER RISER DIAGRAM	10-21-22		
C05	SURVEY	10-21-22			A1.1	PARTIAL FIRST FLOOR PLAN - AREA 100	10-21-22			A10.5	STAR DETAILS	10-21-22			M0.5	MECHANICAL SCHEDULES	10-21-22			PI.10	FIRST FLOOR AREA 700 WATER PLAN	10-21-22	1	11-16-22	E5.4	FIRE ALARM RISER DIAGRAM AND DETAILS	10-21-22		
C06	SURVEY	10-21-22			A1.2	PARTIAL FIRST FLOOR PLAN - AREA 200	10-21-22	2	11-21-22						M0.6	MECHANICAL SCHEDULES	10-21-22			PI.11	FIRST FLOOR AREA 800 WATER PLAN	10-21-22	1	11-16-22	E5.5	PAGING AND EMS RISER DIAGRAM AND DETAILS	10-21-22	1	11-16-22
C07	DEMOLITION & EROSION CONTROL PLAN	10-21-22			A1.3	PARTIAL FIRST FLOOR PLAN - AREA 300	10-21-22								M0.7	MECHANICAL SITE PLAN	10-21-22	2	11-21-22	PI.12	BLDG 4, 5 AND 6 WATER PLAN	10-21-22			E5.6	DATA RISER DIAGRAM	10-21-22	1	11-16-22
C08	MASTER SITE PLAN	10-21-22	1	11-16-22	A1.4	PARTIAL FIRST FLOOR PLAN - AREA 800	10-21-22	2	11-21-22	SN.01	STRUCTURAL GENERAL NOTES	10-21-22			M1.1	FIRST FLOOR AREA 100 HVAC PLAN	10-21-22			P2.1	SECOND FLOOR AREA 100 PLUMBING PLAN	10-21-22	1	11-16-22	E5.7	DATA SYSTEM DETAILS	10-21-22		
C09	SITE PLAN	10-21-22			A1.5	PARTIAL FIRST FLOOR PLAN - AREA 700	10-21-22			SN.02	STRUCTURAL GENERAL NOTES	10-21-22			M1.2	FIRST FLOOR AREA 200 HVAC PLAN	10-21-22			P2.2	SECOND FLOOR AREA 200 PLUMBING PLAN	10-21-22	1	11-16-22	E5.8	DATA SYSTEM DETAILS	10-21-22		
C10	SITE PLAN	10-21-22	1	11-16-22	A1.6	PARTIAL SECOND FLOOR PLAN - AREA 500	10-21-22	2	11-21-22	SN.03	STRUCTURAL GENERAL NOTES	10-21-22			M1.3	FIRST FLOOR AREA 300 HVAC PLAN	10-21-22			P2.3	SECOND FLOOR AREA 300 PLUMBING PLAN	10-21-22	1	11-16-22	E5.9	DATA SYSTEM DETAILS	10-21-22		
C11	SITE PLAN	10-21-22			A1.7	PARTIAL SECOND FLOOR PLAN - AREA 400	10-21-22	2	11-21-22	SN.04	STRUCTURAL GENERAL NOTES / ABBREVIATIONS	10-21-22			M1.4	FIRST FLOOR AREA 700 HVAC PLAN	10-21-22			P3.1	THIRD FLOOR AREA 800 PLUMBING PLAN	10-21-22	1	11-16-22	E5.10	DATA SYSTEM DETAILS	10-21-22		
C12	SITE PLAN	10-21-22	1	11-16-22	A1.8	PARTIAL SECOND FLOOR PLAN - AREA 800	10-21-22	2	11-21-22	SN.05	THRESHOLD INSPECTION PLAN	10-21-22			M1.5	FIRST FLOOR AREA 800 HVAC PLAN	10-21-22			P3.2	THIRD FLOOR AREA 1000 PLUMBING PLAN	10-21-22	1	11-16-22	E5.11	VOICE RISER DIAGRAM AND DETAILS	10-21-22	1	11-16-22
C13	OFFSITE SITE PLAN	10-21-22			A1.9	PARTIAL THIRD FLOOR PLAN - AREA 1000	10-21-22			S0.1	OVERALL FOUNDATION PLAN	10-21-22	1	11-16-22	M2.1	SECOND FLOOR AREA 400 HVAC PLAN	10-21-22			P4.1	PLUMBING ROOF PLAN	10-21-22			E5.12	VOICE SYSTEM DETAILS	10-21-22		
C14	GRADING AND DRAINAGE PLAN	10-21-22			A1.10	ARCHITECTURAL DETAILS	10-21-22			S0.2	OVERALL 2ND FLOOR AND LOW ROOF FRAMING PLAN	10-21-22			M2.2	SECOND FLOOR AREA 500 HVAC PLAN	10-21-22			P5.1	ENLARGED KITCHEN WASTE PLAN	10-21-22			E5.13	VOICE SYSTEM DETAILS	10-21-22		
C15	GRADING AND DRAINAGE PLAN	10-21-22	1	11-16-22	A1.11	ARCHITECTURAL DETAILS	10-21-22			S0.3	OVERALL 3RD FLOOR AND MID ROOF FRAMING PLAN	10-21-22			M2.3	SECOND FLOOR AREA 600 HVAC PLAN	10-21-22			P5.2	ENLARGED KITCHEN WATER PLAN	10-21-22	1	11-16-22	E5.14	SECURITY RISER DIAGRAM AND DETAILS	10-21-22		
C16	GRADING AND DRAINAGE PLAN	10-21-22			A1.12	ARCHITECTURAL DETAILS	10-21-22			S0.4	OVERALL HIGH ROOF FRAMING PLAN	10-21-22			M3.1	THIRD FLOOR AREA 800 HVAC PLAN	10-21-22			P5.3	ENLARGED SCIENCE ROOM PLAN	10-21-22			E5.15	SECURITY SYSTEM DETAILS	10-21-22		
C17	GRADING AND DRAINAGE PLAN	10-21-22	1	11-16-22	A1.13	ARCHITECTURAL DETAILS	10-21-22			S1.1	PARTIAL FOUNDATION PLAN - AREA 100	10-21-22			M3.2	THIRD FLOOR AREA 1000 HVAC PLAN	10-21-22			P6.1	PLUMBING RISER DIAGRAM	10-21-22			E5.16	GPS CLOCK RISER DIAGRAM AND DETAILS	10-21-22		
C18	ROOF DRAIN PLAN	10-21-22			A2.1	OVERALL ROOF PLAN	10-21-22			S1.2	PARTIAL FOUNDATION PLAN - AREA 200	10-21-22			M4.1	FIRST FLOOR AREA 100 MECHANICAL ROOM	10-21-22			P6.2	PLUMBING RISER DIAGRAM	10-21-22			E5.17	BROADBAND RISER DIAGRAM AND DETAILS	10-21-22		
C19	OFFSITE GRADING AND DRAINAGE PLAN	10-21-22			A2.2	ROOF DETAILS	10-21-22			S1.3	PARTIAL FOUNDATION PLAN - AREA 300	10-21-22			M4.2	FIRST FLOOR AREA 200 MECHANICAL ROOM	10-21-22			P6.3	PLUMBING RISER DIAGRAM	10-21-22	1	11-16-22	E5.18	TELECOMMUNICATIONS GROUNDING RISER DIAGRAM AND DETAILS	10-21-22	1	11-16-22
C20	MASTER UTILITY PLAN	10-21-22			A2.3	ROOF DETAILS	10-21-22			S1.4	PARTIAL FOUNDATION PLAN - AREA 800	10-21-22			M4.3	FIRST FLOOR AREA 300 MECHANICAL ROOM	10-21-22			P6.4	PLUMBING RISER DIAGRAM	10-21-22			E5.19	TELECOMMUNICATIONS DETAIL	10-21-22		
C21	UTILITY PLAN	10-21-22			A3.1	EXTERIOR BUILDING ELEVATIONS	10-21-22	2	11-21-22	S1.4R	PARTIAL LOW ROOF FRAMING PLAN - AREA 800	10-21-22			M4.4	FIRST FLOOR AREA 700 MECHANICAL ROOM	10-21-22			P6.5	PLUMBING RISER DIAGRAM	10-21-22			E5.20	TELECOMMUNICATIONS DETAIL	10-21-22		
C22	UTILITY PLAN	10-21-22	1	11-16-22	A3.1A	EXTERIOR BUILDING ELEVATIONS - PAINT	10-21-22			S1.5	PARTIAL FOUNDATION PLAN - AREA 700	10-21-22			M4.5	FIRST FLOOR AREA 800A MECHANICAL ROOM	10-21-22			P6.6	PLUMBING RISER DIAGRAM	10-21-22			E5.21	CCTV RISER DIAGRAM AND DETAILS	10-21-22		
C23	CONSTRUCTION DETAILS	10-21-22			A3.2	EXTERIOR BUILDING ELEVATIONS	10-21-22			S1.5R	PARTIAL LOW ROOF FRAMING PLAN - AREA 700	10-21-22			M4.6	FIRST FLOOR AREA 800B MECHANICAL ROOM	10-21-22							E5.22	TELECOMMUNICATIONS RISER DIAGRAM	10-21-22	1	11-16-22	
C24	CONSTRUCTION DETAILS	10-21-22			A3.2A	EXTERIOR BUILDING ELEVATIONS - PAINT	10-21-22			S1.6	PART. 2ND FLR. FRAMING PLAN - AREA 500 AND LOW ROOF - AREA 100	10-21-22			M4.7	FIRST FLOOR AREA 800C MECHANICAL ROOM	10-21-22							E6.1	LIGHT FIXTURE SCHEDULES	10-21-22			
C25	CONSTRUCTION DETAILS	10-21-22			A3.3	EXTERIOR BUILDING ELEVATIONS	10-21-22	2	11-21-22	S1.7	PARTIAL 2ND FLOOR FRAMING PLAN - AREA 400	10-21-22			M5.1	SECOND FLOOR AREA 400 MECHANICAL ROOM	10-21-22			E0.1	ELECTRICAL DRAWING INDEX	10-21-22			E6.2	MISCELLANEOUS SCHEDULES	10-21-22		
C26	CONSTRUCTION DETAILS	10-21-22			A3.3A	EXTERIOR BUILDING ELEVATIONS - PAINT	10-21-22			S1.7R	PARTIAL 2ND FLOOR FRAMING PLAN - AREA 400	10-21-22			M5.2	SECOND FLOOR AREA 500 MECHANICAL ROOM	10-21-22			E0.2	LEGEND AND GENERAL ELECTRICAL NOTES	10-21-22	1	11-16-22	E6.3	MISCELLANEOUS SCHEDULES	10-21-22		
C27	CONSTRUCTION DETAILS	10-21-22			A3.4	EXTERIOR BUILDING ELEVATIONS	10-21-22			S1.8	PARTIAL 2ND FLOOR FRAMING PLAN - AREA 800	10-21-22			M5.3	THIRD FLOOR AREA 800 MECHANICAL ROOM	10-21-22			E0.3	ELECTRICAL SITE PLAN	10-21-22	2	11-21-22	E6.4	PANEL BOARD SCHEDULES	10-21-22	1	11-16-22
C28	SEWER DETAILS	10-21-22			A3.4A	EXTERIOR BUILDING ELEVATIONS - PAINT	10-21-22			S1.9	PARTIAL 3RD FLOOR FRAMING PLAN - AREA 500	10-21-22			M5.4	CENTRAL ENERGY PLANT MECHANICAL	10-21-22			E0.4	ELECTRICAL SITE LIGHTING PLAN	10-21-22	2	11-21-22	E6.5	PANEL BOARD SCHEDULES	10-21-22	1	11-16-22
C29	SEWER DETAILS	10-21-22			A3.5	EXTERIOR BUILDING ELEVATIONS	10-21-22			S1.9R	PARTIAL HIGH ROOF FRAMING PLAN - AREA 500	10-21-22			M7.2	CENTRAL ENERGY PLANT SCHEMATIC	10-21-22			E0.5	ENLARGED CANOPY LIGHTING PLAN	10-21-22			E6.6	PANEL BOARD SCHEDULES	10-21-22	1	11-16-22
C30	WATER DETAILS	10-21-22			A3.5A	EXTERIOR BUILDING ELEVATIONS - PAINT	10-21-22	2	11-21-22	S1.10	PARTIAL 3RD FLOOR FRAMING PLAN - AREA 800	10-21-22			M7.3	CHILLED WATER PIPING SCHEMATIC	10-21-22			E1.1	AREA 100 LIGHTING PLAN	10-21-22			E6.7	PANEL BOARD SCHEDULES	10-21-22	1	11-16-22
C31	WATER DETAILS	10-21-22			A3.6	EXTERIOR BUILDING ELEVATIONS	10-21-22			S1.10R	PARTIAL HIGH ROOF FRAMING PLAN - AREA 800	10-21-22			M8.1	MECHANICAL DETAILS	10-21-22			E1.2	AREA 200 LIGHTING PLAN	10-21-22			E6.8	PANEL BOARD SCHEDULES	10-21-22	1	11-16-22
C32	WATER DETAILS	10-21-22			A4.1	BUILDING SECTIONS	10-21-22			S1.11	MISC. AMENITY BLDG. PLANS	10-21-22			M8.2	MECHANICAL DETAILS	10-21-22			E1.3	AREA 300 LIGHTING PLAN	10-21-22			E6.9	PANEL BOARD SCHEDULES	10-21-22	1	11-16-22
C33	WATER DETAILS	10-21-22			A4.2	BUILDING SECTIONS	10-21-22	2	11-21-22	S2.1	FOUNDATION SECTIONS AND DETAILS	10-21-22	1	11-16-22	M8.3	MECHANICAL DETAILS	10-21-22			E1.4	AREA 700 LIGHTING PLAN	10-21-22			E6.10	PANEL BOARD SCHEDULES	10-21-22	1	11-16-22
C34	SWPPP	10-21-22			A4.3	BUILDING SECTIONS	10-21-22	2	11-21-22	S2.2	FOUNDATION SECTIONS AND DETAILS	10-21-22			M8.4	MECHANICAL DETAILS	10-21-22			E1.5	AREA 800 LIGHTING PLAN	10-21-22							

LIFE SAFETY SYMBOLS LEGEND


- SMOKE PARTITION CONSTRUCTED WALL. ALL OPENINGS AND MECHANICAL PENETRATIONS SHALL BE PROTECTED TO MAINTAIN THE INTEGRITY OF THE SMOKE PARTITION CONSTRUCTION FOR THE WALL. REFER TO WALL TYPES.
- 1 HOUR FIRE RATED WALL. ALL OPENINGS AND MECHANICAL PENETRATIONS SHALL BE PROTECTED TO MAINTAIN THE INTEGRITY OF THE FIRE RATING FOR THE WALL. REFER TO WALL TYPES FOR UL NUMBERS.
- 2 HOUR FIRE RATED WALL. ALL OPENINGS AND MECHANICAL PENETRATIONS SHALL BE PROTECTED TO MAINTAIN THE INTEGRITY OF THE FIRE RATING FOR THE WALL. REFER TO WALL TYPES FOR UL NUMBERS.
- 3 HOUR FIRE RATED WALL. ALL OPENINGS AND MECHANICAL PENETRATIONS SHALL BE PROTECTED TO MAINTAIN THE INTEGRITY OF THE FIRE RATING FOR THE WALL. REFER TO WALL TYPES FOR UL NUMBERS.
- PRIMARY MEANS OF EGRESS
- SECONDARY MEANS OF EGRESS
- EMERGENCY EXIT LIGHT (CEILING MTD.)
- EMERGENCY EXIT LIGHT (WALL MTD.)
- PHOTOLUMINESCENT EMERGENCY EXIT LIGHT (CEILING MTD.)
- PHOTOLUMINESCENT EMERGENCY EXIT LIGHT (WALL MTD.)
- (NOTE: EXIT LIGHT ARROWS INDICATE LIGHTED DIRECTIONAL SIGNAGE)

- FIRE EXTINGUISHER & CABINET
- WALL HUNG FIRE EXTINGUISHER
- DOOR FIRE RATING IN MINUTES
- OCCUPANT LOAD
- OPENING EGRESS CAPACITY
- EMERGENCY LIGHT
- INDICATES 2 HR FIRE RATED UL DES. # FLOOR/CEILING OR ROOF ASSEMBLY
- INDICATES 1 HR FIRE RATED UL DES. # FLOOR/CEILING OR ROOF ASSEMBLY
- NOTE: PROVIDE STENCILING ON WALLS ABOVE CEILING FOR PROTECTED WALLS STATING FIRE AND/OR SMOKE BARRIER PROTECT ALL OPENINGS (TYPICAL FOR ALL RATED PARTITIONS)


BUILDING INFORMATION

3 HR FIRE RESISTANCE RATING SEPARATING THE FOLLOWING AREAS OF THE BUILDING:			
AREA #1			
TYPE II B CONSTRUCTION	FIRST FLOOR =	21,280 SF	
SPRINKLERED	SECOND FLOOR =	20,576 SF	
OCCUPANCY: E - EDUCATIONAL	TOTAL =	41,856 SF	
PER FBC 508.3 AUTOMATIC SPRINKLER SYSTEM INCREASE: I = 200% X 14,500 SF (ALLOWABLE FROM TABLE 503) = 29,000 TOTAL SF. PER FLOOR ALLOWED FOR THE MULTISTORY BUILDING.			
AREA #2			
TYPE II B CONSTRUCTION	FIRST FLOOR =	52,424 SF	
SPRINKLERED	SECOND FLOOR =	28,275 SF	
OCCUPANCY: E - EDUCATIONAL	THIRD FLOOR =	28,275 SF	
	TOTAL =	108,974 SF	
PER FBC 508.3 AUTOMATIC SPRINKLER SYSTEM INCREASE: I = 300% X 14,500 SF (ALLOWABLE FROM TABLE 503) = 43,500 TOTAL SF. FOR A SINGLE STORY BUILDING.			
AREA #3			
TYPE II B CONSTRUCTION	FIRST FLOOR =	39,125 SF	
SPRINKLERED			
OCCUPANCY: E - EDUCATIONAL	TOTAL =	39,125 SF	
PER FBC 508.3 AUTOMATIC SPRINKLER SYSTEM INCREASE: I = 300% X 14,500 SF (ALLOWABLE FROM TABLE 503) = 43,500 TOTAL SF. FOR A SINGLE STORY BUILDING.			
GROSS BUILDING TOTAL			
		189,955 SF	
LIFE SAFETY SYSTEM:			
Emergency Lighting and Exit Signs	☒ Yes	☐ No	
Fire Alarm and Smoke Detection Systems	☒ Yes	☐ No	
Panic Hardware	☒ Yes	☐ No	
EXIT REQUIREMENTS:			
Dead end limit-maximum condition	20	Feet	
Travel distance to exit-maximum condition	200	Feet	


1ST FLR CONSTRUCTION TYPE DIAGRAM

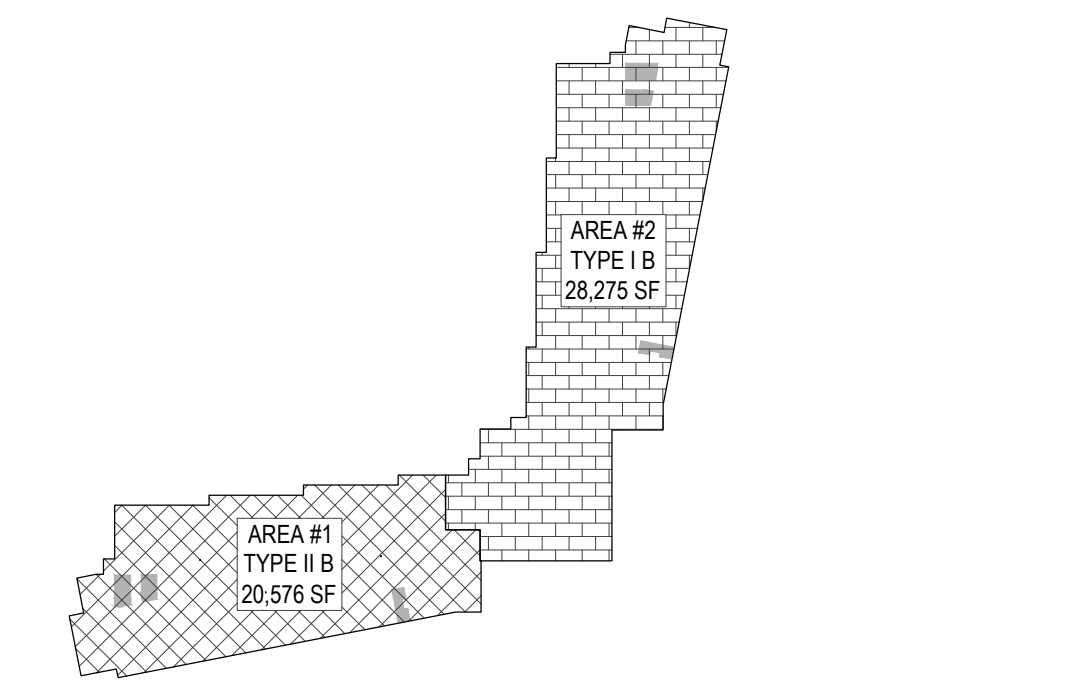

2ND FLR CONSTRUCTION TYPE DIAGRAM

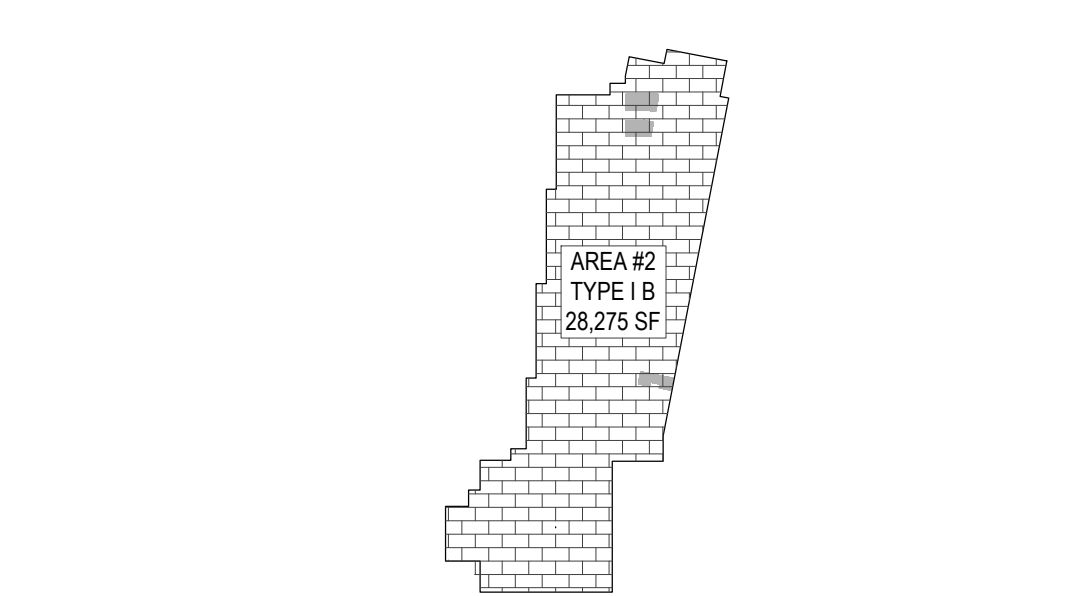

3RD FLR CONSTRUCTION TYPE DIAGRAM

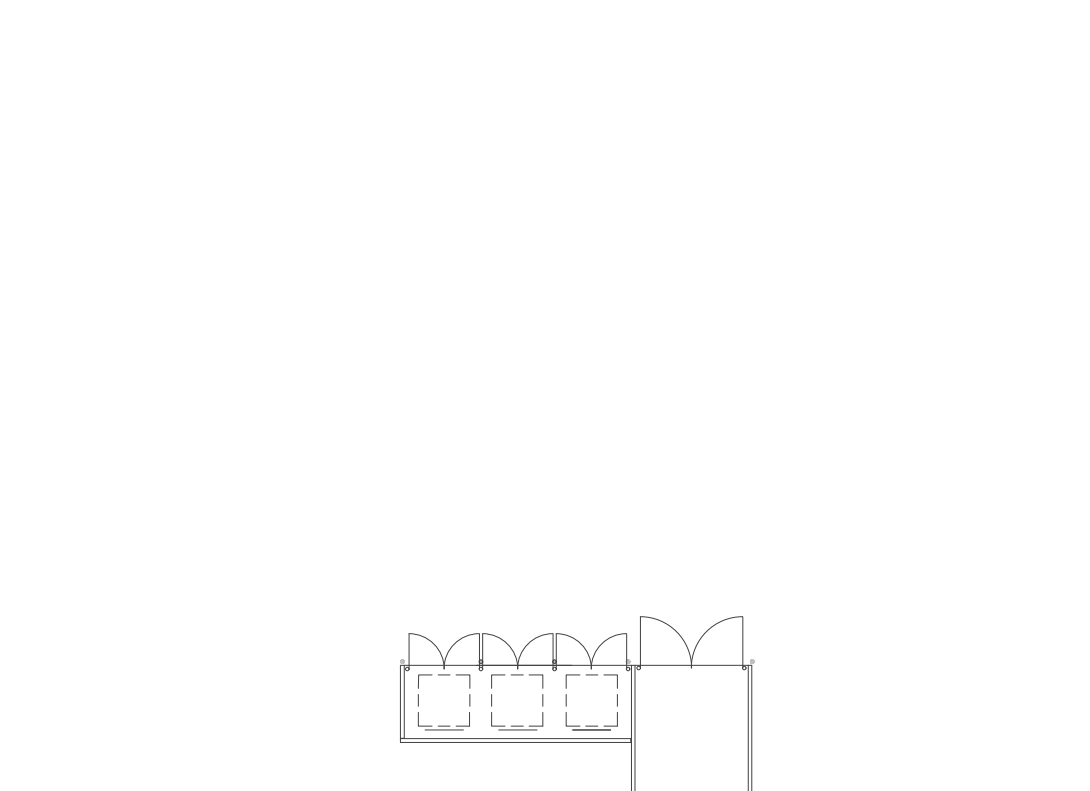

GEN. / DUMPSTER LIFE SAFETY PLAN

1/30" = 1'-0"

THIRD FLOOR ROOF LIFE SAFETY PLAN

1/30" = 1'-0"

OVERALL 3RD FLOOR LIFE SAFETY PLAN

1/30" = 1'-0"

OVERALL CHILLER LIFE SAFETY PLAN

1/30" = 1'-0"

OVERALL P.E. PAVILION LIFE SAFETY PLAN

1/30" = 1'-0"

BUILDING AREA 900	
ROOM #	ROOM NAME
049	CORRIDOR
050	VESTIBULE
051	CORRIDOR
051A	CORRIDOR
052	CORRIDOR
077	STAIR
080	STAIR
900	MECHANICAL
901	ELECTRICAL
902	CUSTODIAL
903	RESE FULL TIME
903A	MATERIAL STORAGE
903B	GIRLS RESTROOM
903C	BOYS RESTROOM
904	MIDDLE SCHOOL SCIENCE
905	TECHNOLOGY / INDUSTRY LAB
906	DATA
907	MATERIAL STORAGE / CUSTODIAL
908	MIDDLE SCHOOL CLASSROOM
909	SUPPLEMENTAL CLASSROOM
910	NOT USED
911	RESE PART-TIME
912	STAFF RESTROOM - MALE
913	MIDDLE SCHOOL CLASSROOM
914	MIDDLE SCHOOL CLASSROOM
915	TEACHER PLANNING
915A	RESTROOM
916	SKILLS LAB
917	MIDDLE SCHOOL CLASSROOM
918	EXTENDED LEARNING AREA
919	MIDDLE SCHOOL CLASSROOM
920	GIRLS RESTROOM
921	BOYS RESTROOM
922	MIDDLE SCHOOL CLASSROOM
923	RESOURCE ROOM/MATERIAL STORAGE
924	MIDDLE SCHOOL CLASSROOM
925	MIDDLE SCHOOL CLASSROOM
BUILDING AREA 1000	
ROOM #	ROOM NAME
047	CORRIDOR
048	CORRIDOR
049	STAIR
013	ELEVATOR
1000	EXTENDED LEARNING AREA
1001	DATA ROOM
1002	BUSINESS LAB
1003	MIDDLE SCHOOL SCIENCE
1003A	MATERIAL STORAGE
1003B	PRODUCT STORAGE
1004	MIDDLE SCHOOL SCIENCE
1004A	PRODUCT STORAGE
1004B	MATERIAL STORAGE
BUILDING AREA 1100	
ROOM #	ROOM NAME
1100	ICE STORAGE
1101	PUMP ROOM
1102	CHILLER YARD
BUILDING AREA 1200	
ROOM #	ROOM NAME
1200	PE PAVILION
1200A	BOYS RESTROOM
1200B	GIRLS RESTROOM
1201	
BUILDING AREA 1300	

K-8 SCHOOL "OO"
ST. JOHNS COUNTY SCHOOL DISTRICT - BID # 2022-50
1455 TWIN CREEKS DRIVE,
ST. AUGUSTINE, FLORIDA 32095

Comm. No:		22046.00
Date:		10-21-22
Drawn:		
Revisions		
No.	Date	Note
1	11-16-22	ADDENDUM 1
3	11-28-22	ADDENDUM 3


TO THE BEST OF MY KNOWLEDGE, THE PLANS AND SPECIFICATIONS COMPLY WITH THE MINIMUM BUILDING CODES.

© 2022 HARVARD JOLLY, INC.

LS0.2

HARVARD JOLLY ARCHITECTURE
2047 Vista Parkway, Suite 100, West Palm Beach, FL 33411 | 561-478-4457 | www.HarvardJolly.com | AR0013140


This information is intended to be used by the owner, architect, engineer, contractor, and other parties involved in the project. It is not to be used for any other purpose. The user hereby acknowledges that the use of this information is at their own risk and that they will be responsible for any consequences of the use of this information.

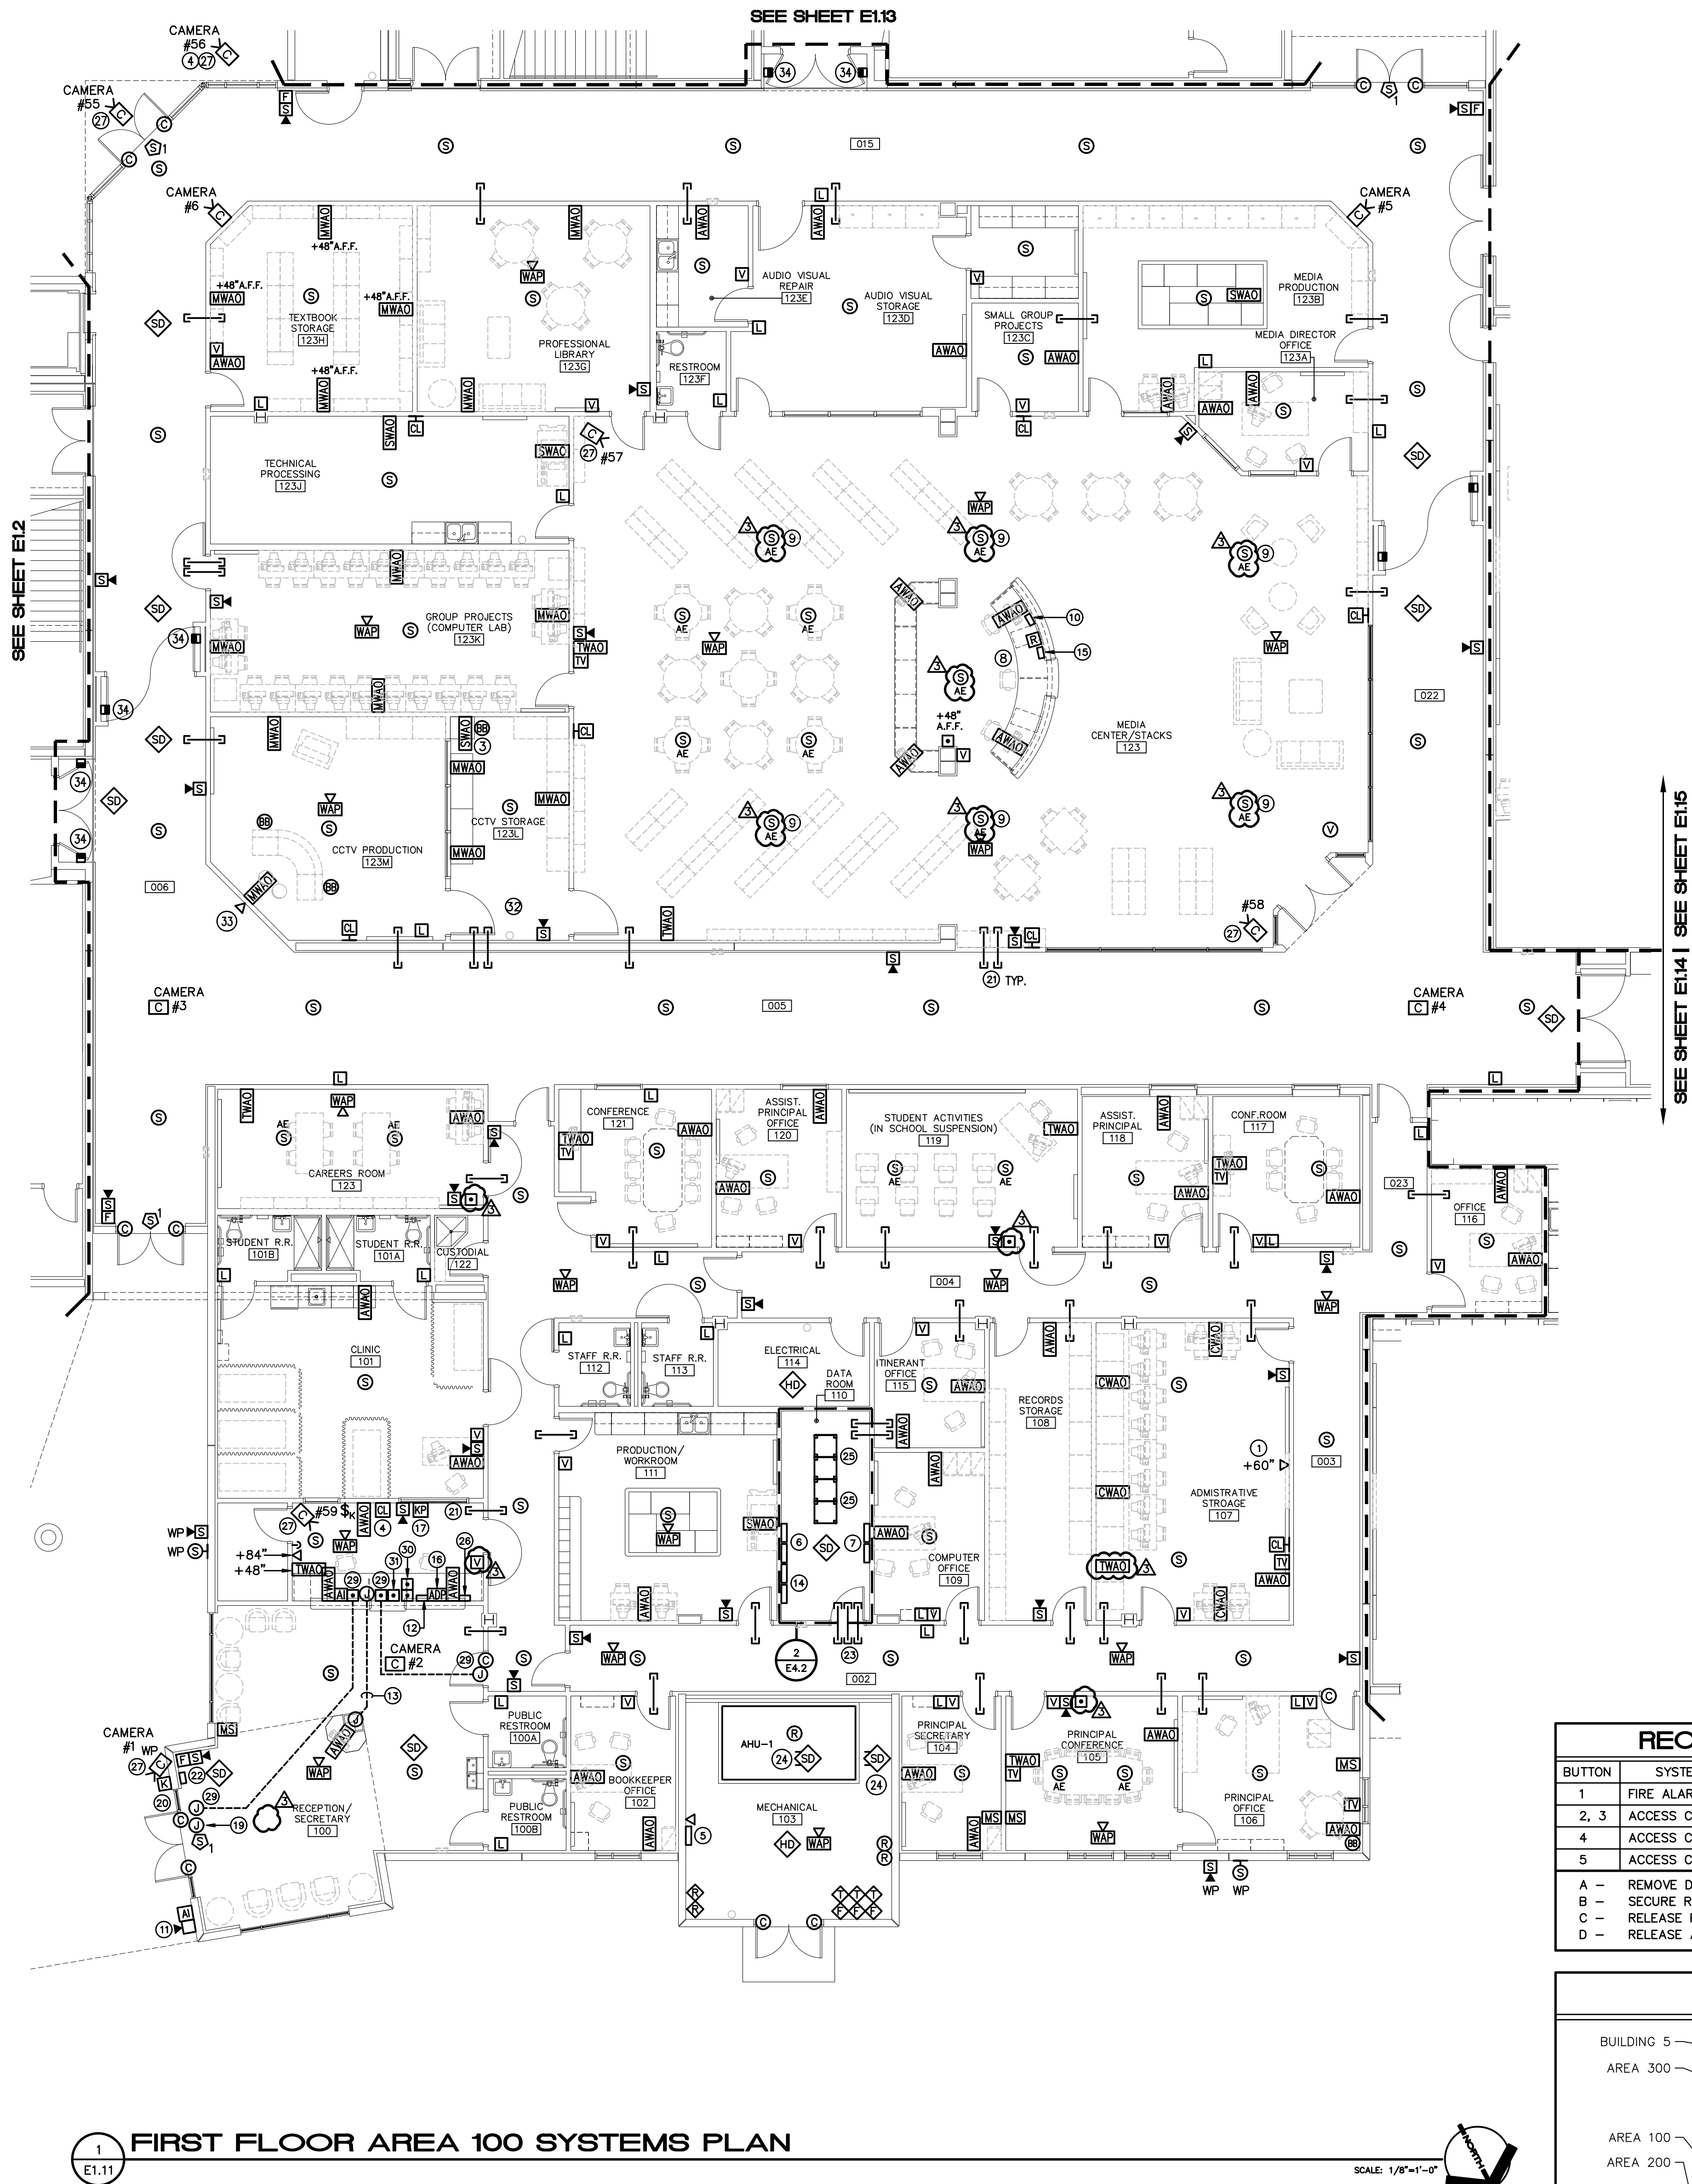

1 E1.11 FIRST FLOOR AREA 100 SYSTEMS PLAN

SCALE: 1/8"=1'-0"

RECEPTION BUTTON MATRIX				
BUTTON	SYSTEM	ACTION	RESULT	SEE PLAN NOTE
1	FIRE ALARM	A	VISUAL BARRIERS IN PLATE	NOTE 31
2, 3	ACCESS CONTROL	B	RESTRICT ACCESS	NOTE 30
4	ACCESS CONTROL	C	FREE TO ENTER RECEPTION	NOTE 29
5	ACCESS CONTROL	D	FREE TO ENTER ADMIN	NOTE 29
A - REMOVE DOOR HOLD POWER AND CALL EMERGENCY SERVICE				
B - SECURE RESTRICTED DOORS				
C - RELEASE FRONT DOOR				
D - RELEASE ADMIN DOOR				

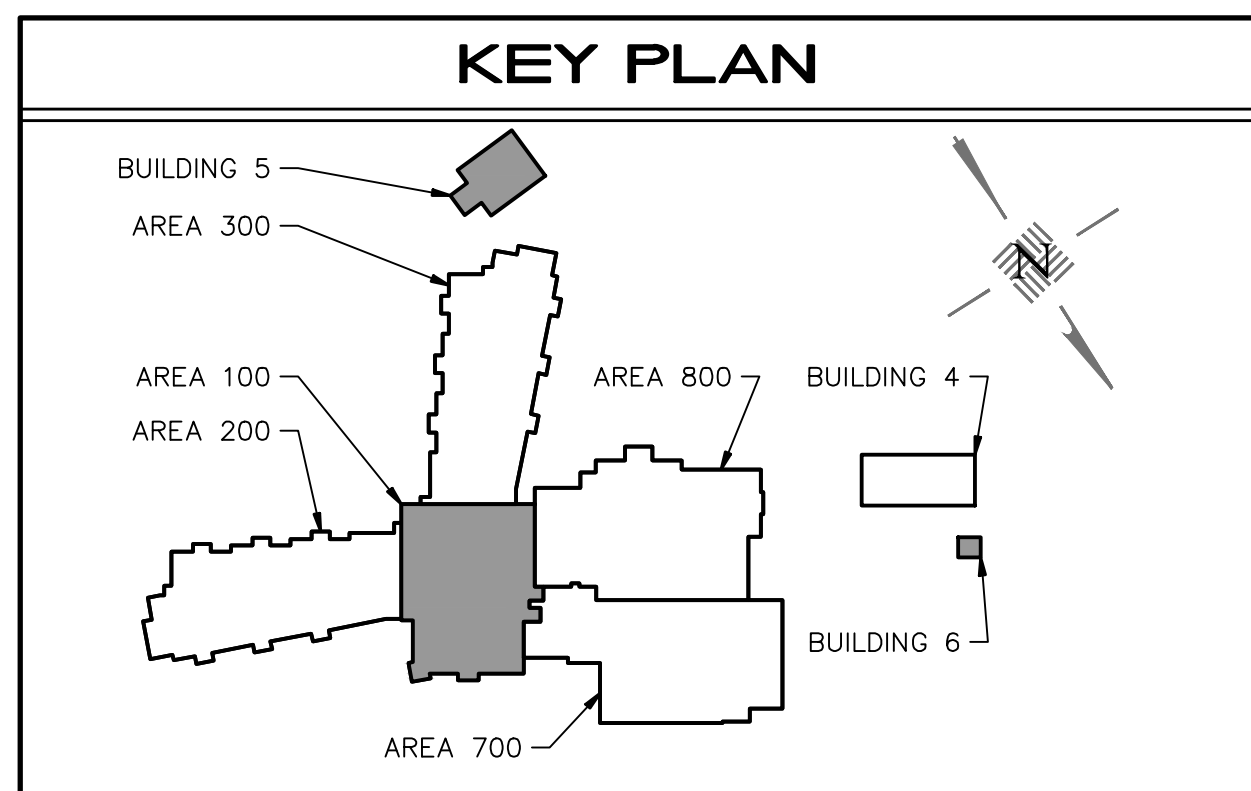

GENERAL NOTE


VERIFY WORK AREA OUTLET CONFIGURATION WITH OWNER PRIOR TO ROUGH-IN. SEE SHEET E7.3 FOR DETAILS.

SYSTEM PLAN NOTES

- DATA OUTLET FOR PROJECTOR. SEE DETAIL 1/E-7.3.
- SEE DETAIL 1/E7.3 FOR SYSTEM OUTLETS MEDIA SHELF AND AT THE TEACHER'S STATION. CONTRACTOR SHALL VERIFY THE EXACT LOCATION OF ALL CASEWORK PRIOR TO ROUGH-IN OF ALL DEVICES.
- BROADBAND HEADEND EQUIPMENT.
- COORDINATE CAMERA MOUNTING LOCATION WITH OWNER PRIOR TO ROUGH-IN.
- EMS CONTROL PANEL.
- MAIN INTRUSION DETECTION CONTROL PANEL AND TERMINAL CABINET.
- MAIN ACCESS CONTROL PANEL AND TERMINAL CABINET.
- FIRE ALARM RELAY FOR SILENCING OF LOCAL SOUND SYSTEM UPON ALARM CONDITION.
- LOCAL SOUND SYSTEM SPEAKER.
- LOCAL SOUND SYSTEM.
- SECURITY SYSTEM ALARM SIREN.
- MARQUEE SIGN CONTROL LOCATION WITH 3/4" C TO SIGN FOR CONTROL WIRING.
- PROVIDE JUNCTION BOX FOR A USB INPUT AND 3/4" C FOR CABLE RUN FROM PILLAR IN FRONT ENTRANCE TO THE FRONT DESK.
- MAIN FIRE ALARM CONTROL PANEL AND TERMINAL CABINET.
- LOCAL AE AMPLIFIER.
- ADMINISTRATIVE DISPLAY PHONE (ADP).
- KEYPAD FOR SECURITY SYSTEM.
- LOCAL SOUND SYSTEM MICROPHONE OUTLET.
- J-BOX FOR DOOR RELEASE WITH CONNECTING 3/4" C.
- KNOX-BOX, 1/4" PLATE STEEL HOUSING, 1/2" THICK DOOR WITH INTERIOR GASKET SEAL. BOTH BOX AND LOCK SHALL HAVE 1/8" STEEL DUST COVER WITH TAMPER SEAL. MOUNTING CAPABILITY. FINISH COLOR SHALL BE ALUMINUM.
- 2" CONDUIT SLEEVES, QUANTITY AS SHOWN, FOR WIRING FROM ROOM TO CABLETRAY.
- FIRE ALARM ANNUNCIATOR PANEL.
- 3-3" CONDUIT SLEEVES.
- NFPA REQUIREMENTS STATE THAT SAMPLING TUBES MUST EXTEND AT LEAST TWO-THIRDS OF THE WAY INTO THE DUCT AND THOSE THAT ARE GREATER THAN 36 INCHES LONG MUST BE SUPPORTED AT BOTH ENDS. TO MEET THIS REQUIREMENT, DRILL A HOLE ON THE OPPOSITE SIDE OF THE DUCT. EXTEND THE SAMPLING TUBE THROUGH THE HOLE. CUT OFF THE EXCESS SAMPLING TUBE AND SEAL THE OPENING AROUND THE TUBE WITH AN APPROVED SEALANT.
- FLOOR MOUNTED I.T. DATA RACK.
- EMERGENCY RADIO AND ANTENNA J-BOX WITH CONNECTING 1 1/2" C. FOR ANTENNA CONDUCTOR.
- VERIFY MOUNTING HEIGHT AND LOCATION WITH OWNER PRIOR TO ROUGH-IN.
- PEDESTAL MOUNTED CARD READER. COORDINATE MOUNTED TYPE, LOCATION, AND REQUIREMENTS WITH OWNER/ARCHITECT PRIOR TO ROUGH-IN.
- PROVIDE 3/4" C. FOR PUSHBUTTON CONTROL OF ELECTRIC STRIKE DOOR RELEASE. DEVICE LOCATED WITHIN SCHLAGE 8200-SERIES DESK CONSOLE OR EQUAL. OWNER TO VERIFY MOUNTING LOCATION PRIOR TO ROUGH-IN.
- PROVIDE TWO SILENT DURESS ALARM MOUNTED UNDER FRONT DESK TO SECURE ALL RESTRICTED DOORS IN 'LOCK DOWN' MODE VIA THE ACCESS CONTROL SYSTEM. DEVICE LOCATED WITHIN SCHLAGE 8200-SERIES DESK CONSOLE OR EQUAL. OWNER TO VERIFY MOUNTING LOCATION PRIOR TO ROUGH-IN.
- PROVIDE PUSHBUTTON WITH COVER COORDINATED WITH FIRE ALARM SYSTEM TO REMOVE POWER TO ELECTRO-MAGNETIC DOOR HOLDERS. TO AUTOMATICALLY DIAL EMERGENCY SERVICES VIA BURGLAR ALARM SYSTEM. DEVICE LOCATED WITHIN SCHLAGE 8200-SERIES DESK CONSOLE OR EQUAL. OWNER TO VERIFY MOUNTING LOCATION PRIOR TO ROUGH-IN.
- TERMINATE CCTV SERVICE INTO THIS ROOM.
- DATA OUTLET FOR MONITOR MOUNTED 24" BELOW CEILING HEIGHT. VERIFY EXACT MOUNTING LOCATION WITH OWNER PRIOR TO ROUGH-IN.
- COORDINATE DOOR HOLDER LOCATION WITH DOOR SWING PRIOR TO ROUGH-IN. WHERE CATCH PLATE EXTENSIONS ARE REQUIRED, USE MANUFACTURER SPECIFIC UL LISTED PARTS. ALL THREAD OR CHAINLINK TYPE EXTENSIONS AND EXTENSIONS OVER 8 INCHES ARE NOT PERMITTED.

Revisions		
No.	Date	Note
3	11/28/22	ADDENDUM 3

TO THE BEST OF MY KNOWLEDGE, THE PLANS AND SPECIFICATIONS COMPLY WITH THE MINIMUM BUILDING CODES.

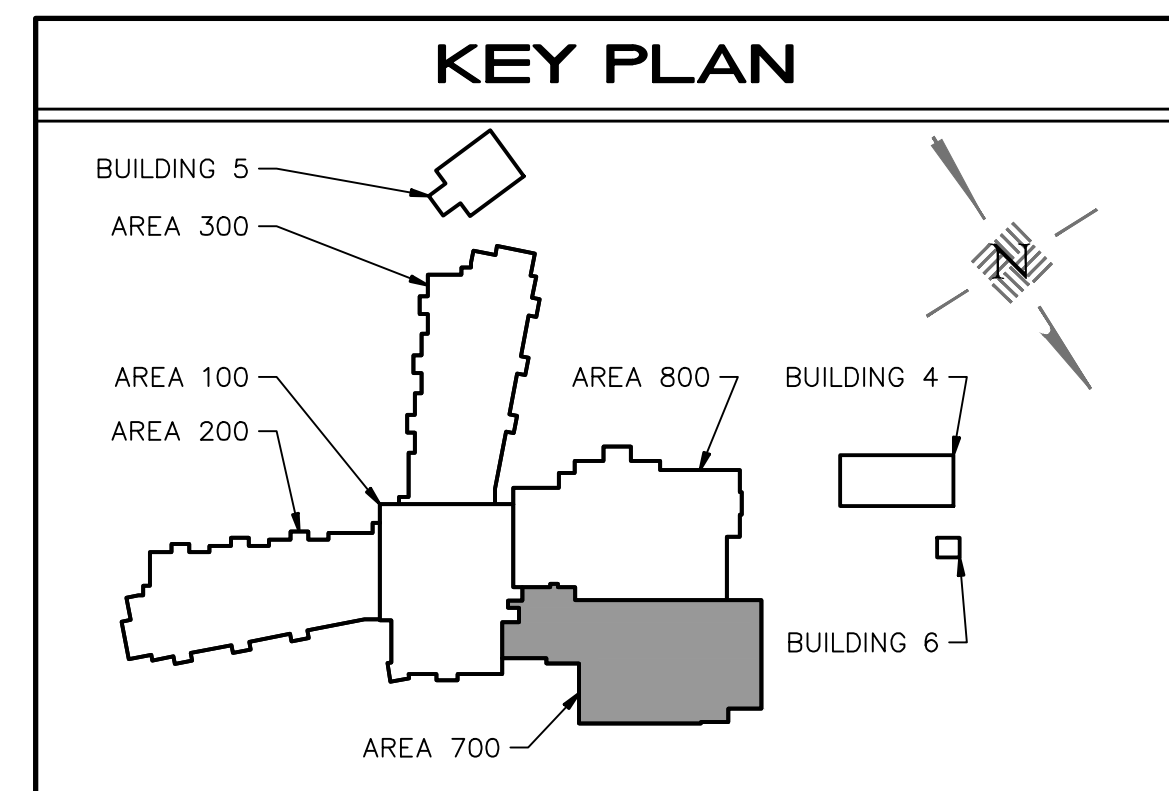

This information contained herein is the property of Johnson, Levinson, Ragan, Davis, Inc. (JLRDI) and is intended for the use of the recipient only. It is not to be distributed, copied, or otherwise used in any manner without the prior written consent of JLRDI. The user hereby acknowledges that all information contained herein is confidential and shall remain the property of JLRDI. The user hereby agrees to hold JLRDI harmless from any and all claims, damages, losses, and expenses, including reasonable attorneys' fees, that may be incurred by JLRDI as a result of the use of this information by the user. The user hereby agrees to hold JLRDI harmless from any and all claims, damages, losses, and expenses, including reasonable attorneys' fees, that may be incurred by JLRDI as a result of the use of this information by the user.

1
E1.17
BUILDING 5 LIGHTING PLAN
SCALE: 1/8"=1'-0"
NORTH


- LIGHTING PLAN NOTES**
1. CONNECT EXTERIOR LIGHTING TO CIRCUIT '3NLB-3' VIA CONTACTOR 'CT-4B'. COORDINATE WITH ARCHITECTURAL FEATURES AND DOWNSPOUTS PRIOR TO ROUGH-IN.
 2. CONNECT PAVILLION LIGHTING TO CIRCUIT '3NLB-5' VIA CONTACTOR 'CT-4B'.

3
E1.17
BUILDING 5 SYSTEMS PLAN
SCALE: 1/8"=1'-0"
NORTH

- SYSTEM PLAN NOTES**
1. EMS CONTROL PANEL.
 2. FIRE ALARM CONTROL PANEL.
 3. COORDINATE EXACT LOCATION OF PIV DEVICES WITH CIVIL PRIOR TO BID.
 4. VERIFY MOUNTING HEIGHT AND LOCATION WITH OWNER PRIOR TO ROUGH-IN.
 5. PROVIDE WALL MOUNTED CAMERA CENTERED ON WALL MOUNTED 9'-11" ABOVE SLAB.
 6. INTRUSION DETECTION TERMINAL CABINET.
 7. IT DATA TERMINAL CABINET.
 8. IRRIGATION CONTROLS. VERIFY EXACT LOCATION WITH IRRIGATION CONTRACTOR PRIOR TO ROUGH-IN.

2
E1.17
BUILDING 5 POWER PLAN
SCALE: 1/8"=1'-0"
NORTH


- POWER PLAN NOTES**
1. EMS CONTROL PANEL. CONNECT TO CIRCUIT INDICATED.
 2. FIRE ALARM TERMINAL CABINET. CONNECT TO CIRCUIT INDICATED.
 3. DISCONNECT 'DS-3NTB'.
 4. LOCATE RECEPTACLE WITHIN DRINKING FOUNTAIN ENCLOSURE. COORDINATE LOCATION WITH DIVISION 22 PRIOR TO ROUGH-IN.
 5. IRRIGATION CONTROLS. VERIFY EXACT LOCATION WITH IRRIGATION CONTRACTOR PRIOR TO ROUGH-IN. CONNECT TO CIRCUIT INDICATED.
 6. INTRUSION DETECTION TERMINAL CABINET. CONNECT TO CIRCUIT INDICATED.
 7. I.T. TERMINAL CABINET. CONNECT TO CIRCUIT INDICATED.
 8. TRANSFORMER '3NTB'.
 9. PANEL '3NLB'.

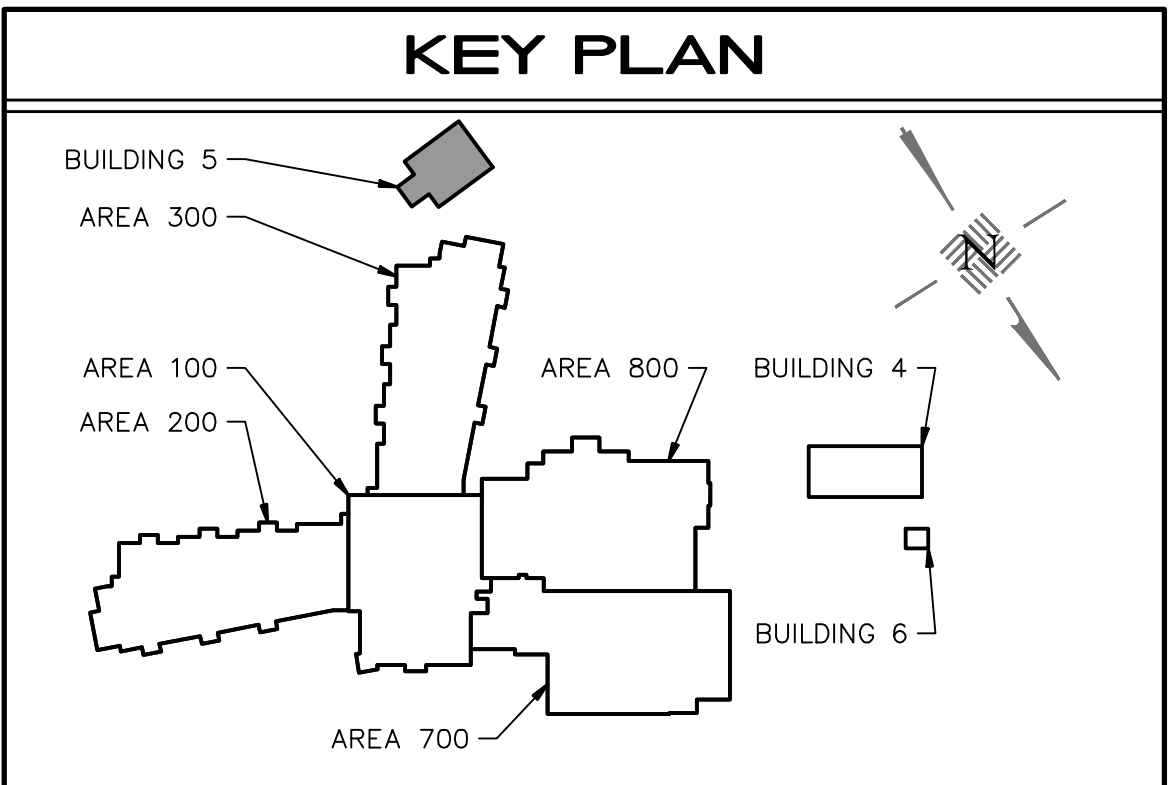


Comm. No: 22046.00		
Date: 10-21-22		
Drawn: JJP		
Revisions		
No.	Date	Note
1	11/16/22	ADDENDUM 1
2	11/21/22	ADDENDUM 2
3	11/28/22	ADDENDUM 3

TO THE BEST OF MY KNOWLEDGE, THE PLANS AND SPECIFICATIONS COMPLY WITH THE MINIMUM BUILDING CODES.

Xref: \\Constructs\HW BORDFR.dwg 7

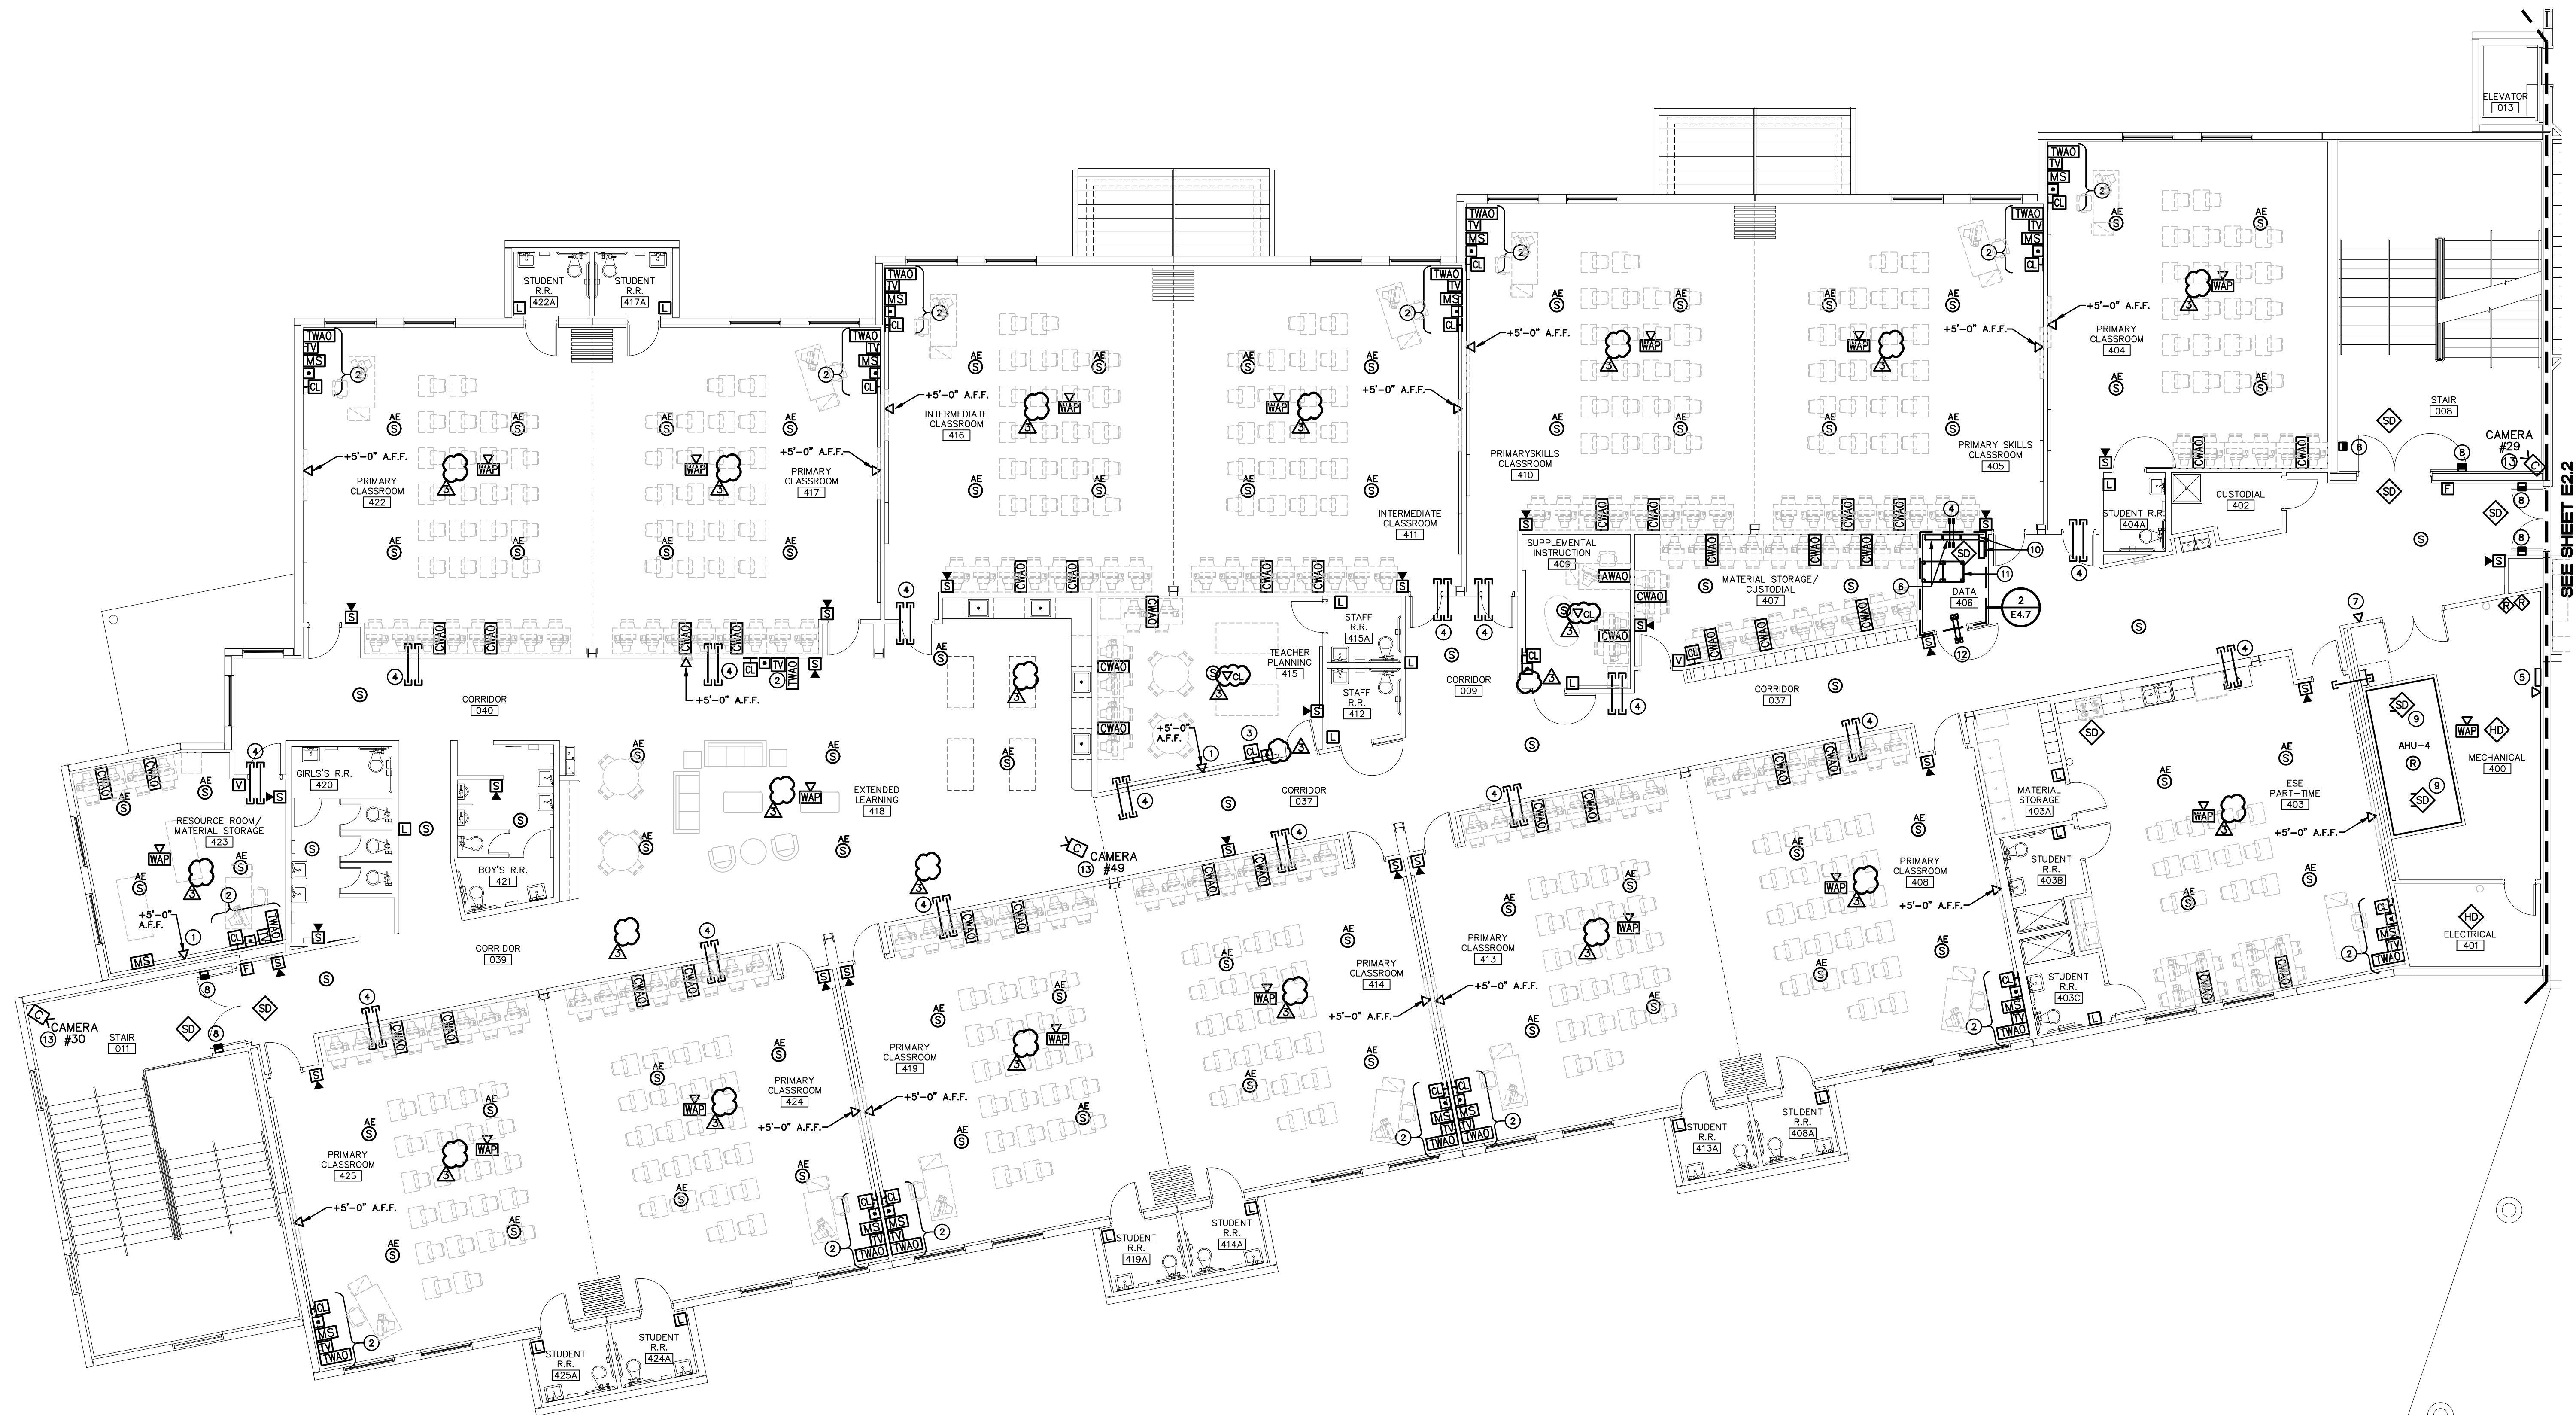

1
E2.7 SECOND FLOOR AREA 400 SYSTEMS PLAN

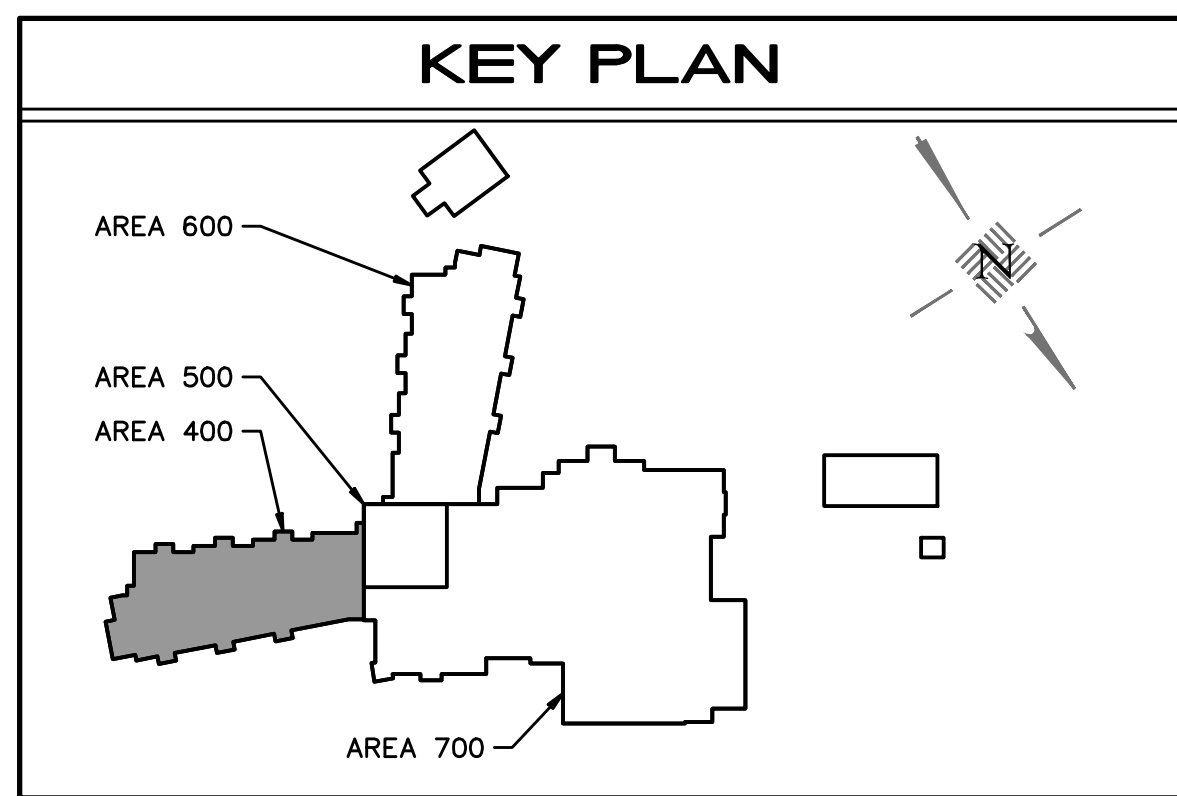

GENERAL NOTE

VERIFY WORK AREA OUTLET CONFIGURATION WITH OWNER PRIOR TO ROUGH-IN. SEE SHEET E7.3 FOR DETAILS.



SYSTEM PLAN NOTES

- 1 MOUNTING BRACKET FOR PROJECTOR. SEE DETAIL 1/E7.3.
- 2 SEE DETAIL 1/E7.3 FOR SYSTEM OUTLETS MEDIA SHELF AND AT THE TEACHER'S STATION. CONTRACTOR SHALL VERIFY THE EXACT LOCATION OF ALL CASEWORK PRIOR TO ROUGH-IN OF ALL DEVICES.
- 3 BUILDING CLOCK/ TRANSMITTER.
- 4 2" CONDUIT SLEEVES, QUANTITY AS SHOWN, FOR WIRING FROM ROOM TO CABLETRAY.
- 5 EMS CONTROL PANEL.
- 6 FIRE ALARM CONTROL PANEL AND TERMINAL CABINET.
- 7 DATA OUTLET FOR MONITOR MOUNTED 24" BELOW CEILING HEIGHT. VERIFY EXACT MOUNTING LOCATION WITH OWNER PRIOR TO ROUGH-IN.
- 8 COORDINATE DOOR HOLDER LOCATION WITH DOOR SWING PRIOR TO ROUGH-IN. WHERE CATCH PLATE EXTENSIONS ARE REQUIRED, USE MANUFACTURER SPECIFIC UL LISTED PARTS. ALL-THREAD OR CHAINLINK TYPE EXTENSIONS AND EXTENSIONS OVER 8 INCHES ARE NOT PERMITTED.
- 9 NFPA REQUIREMENTS STATE THAT SAMPLING TUBES MUST EXTEND AT LEAST TWO-THIRDS OF THE WAY INTO THE DUCT AND THOSE THAT ARE GREATER THAN 36 INCHES LONG MUST BE SUPPORTED AT BOTH ENDS. TO MEET THIS REQUIREMENT, DRILL A HOLE ON THE OPPOSITE SIDE OF THE DUCT. EXTEND THE SAMPLING TUBE THROUGH THE HOLE. CUT OFF THE EXCESS SAMPLING TUBE AND SEAL THE OPENING AROUND THE TUBE WITH AN APPROVED SEALANT.
- 10 INTRUSION DETECTION CONTROL PANEL AND TERMINAL CABINET.
- 11 FLOOR MOUNTED I.T. DATA RACK.
- 12 2-3" CONDUIT SLEEVES.
- 13 VERIFY MOUNTING HEIGHT AND LOCATION WITH OWNER PRIOR TO ROUGH-IN.

Revisions		
No.	Date	Note
3	11/28/22	ADDENDUM 3

TO THE BEST OF MY KNOWLEDGE, THE PLANS AND SPECIFICATIONS COMPLY WITH THE MINIMUM BUILDING CODES.

The information contained herein is the property of Johnson, Levinson, Ragan, Davila, Inc. (JLRD) and is intended for the use of the client only. It is not to be reproduced, stored in a retrieval system, or transmitted in any form or by any means, electronic, mechanical, photocopying, recording, or by any information storage and retrieval system, without the prior written permission of JLRD. The user hereby represents and warrants that the information contained herein, and without full certification in the same, shall be used only for the purposes intended and shall not be used for any other purpose. The user hereby represents and warrants that the information contained herein, and without full certification in the same, shall be used only for the purposes intended and shall not be used for any other purpose.

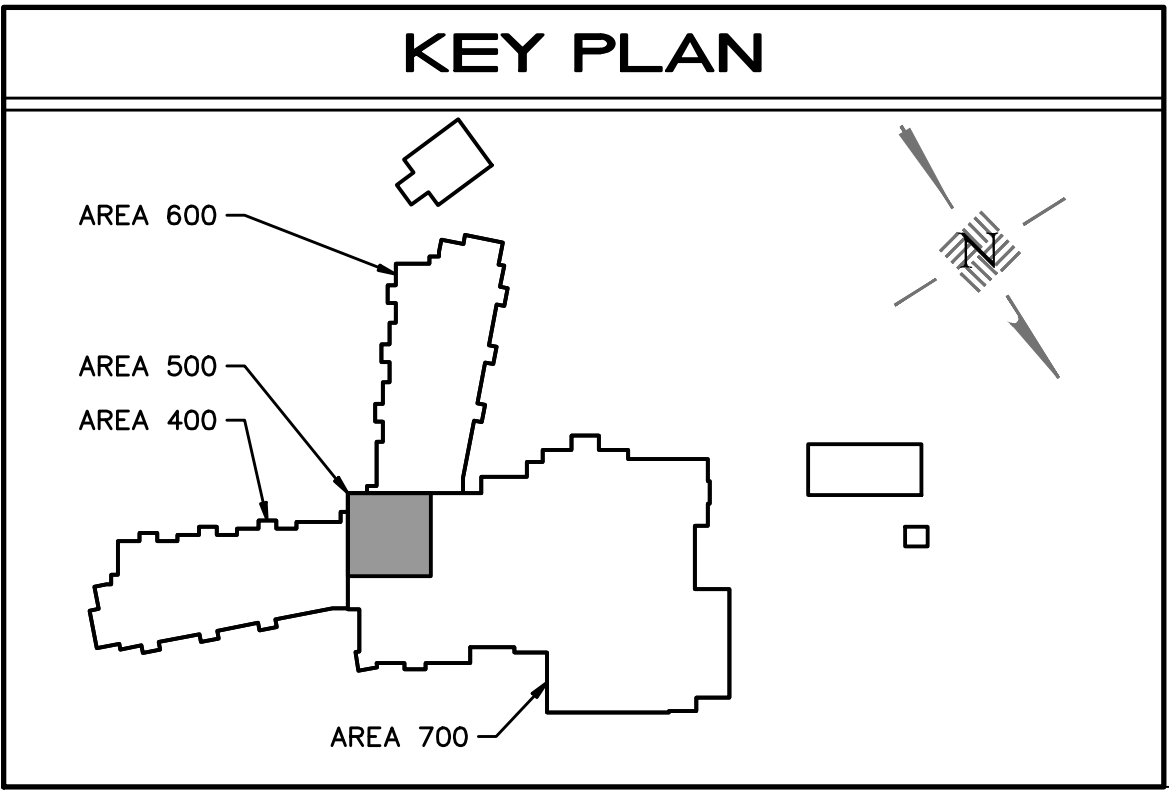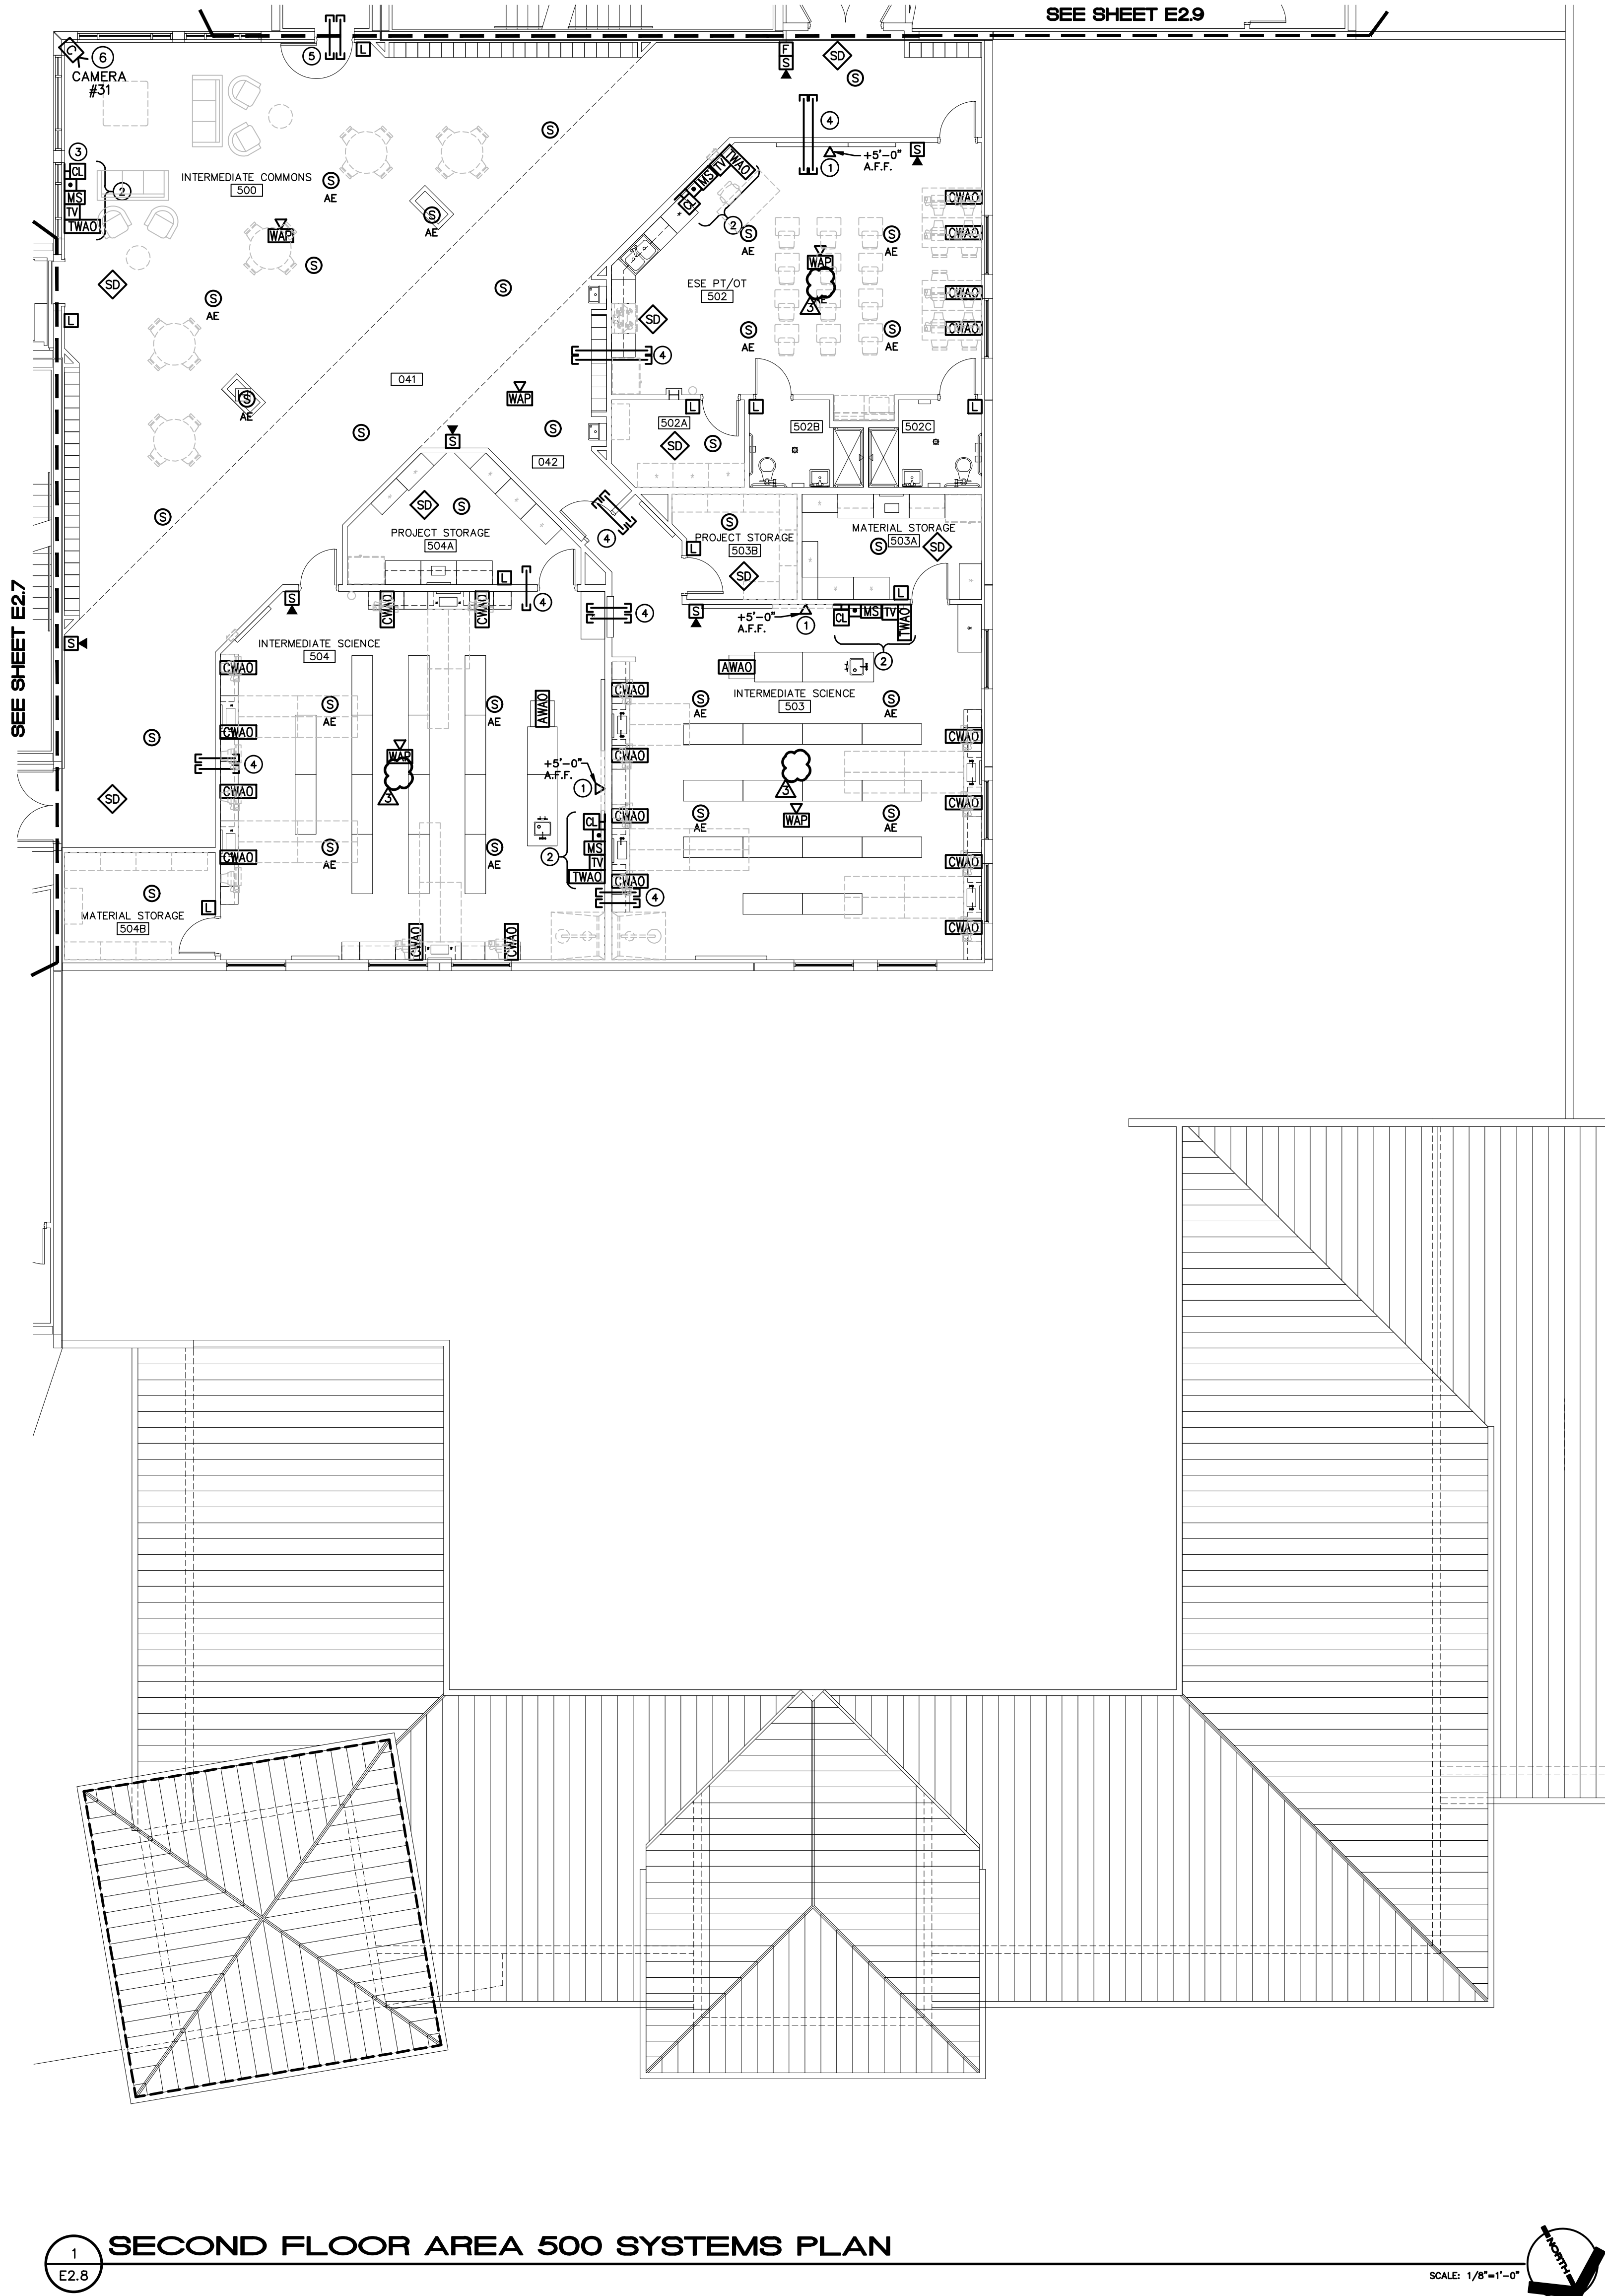


GENERAL NOTE

VERIFY WORK AREA OUTLET CONFIGURATION WITH OWNER PRIOR TO ROUGH-IN. SEE SHEET E7.3 FOR DETAILS.

- SYSTEM PLAN NOTES**
- DATA OUTLET FOR PROJECTOR. SEE DETAIL 1/E7.3.
 - SEE DETAIL 1/E7.3 FOR SYSTEM OUTLET'S MEDIA SHELF AND AT THE TEACHER'S STATION. CONTRACTOR SHALL VERIFY THE EXACT LOCATION OF ALL CASEWORK PRIOR TO ROUGH-IN OF ALL DEVICES.
 - BUILDING CLOCK/ TRANSMITTER.
 - 2" CONDUIT SLEEVES, QUANTITY AS SHOWN, FOR WIRING FROM ROOM TO CABLETRAY.
 - 2-3" CONDUIT SLEEVES TO DATA ROOM 501.
 - VERIFY MOUNTING HEIGHT AND LOCATION WITH OWNER PRIOR TO ROUGH-IN.

Revisions		
No.	Date	Note
3	11/28/22	ADDENDUM 3

TO THE BEST OF MY KNOWLEDGE, THE PLANS AND SPECIFICATIONS COMPLY WITH THE MINIMUM BUILDING CODES.

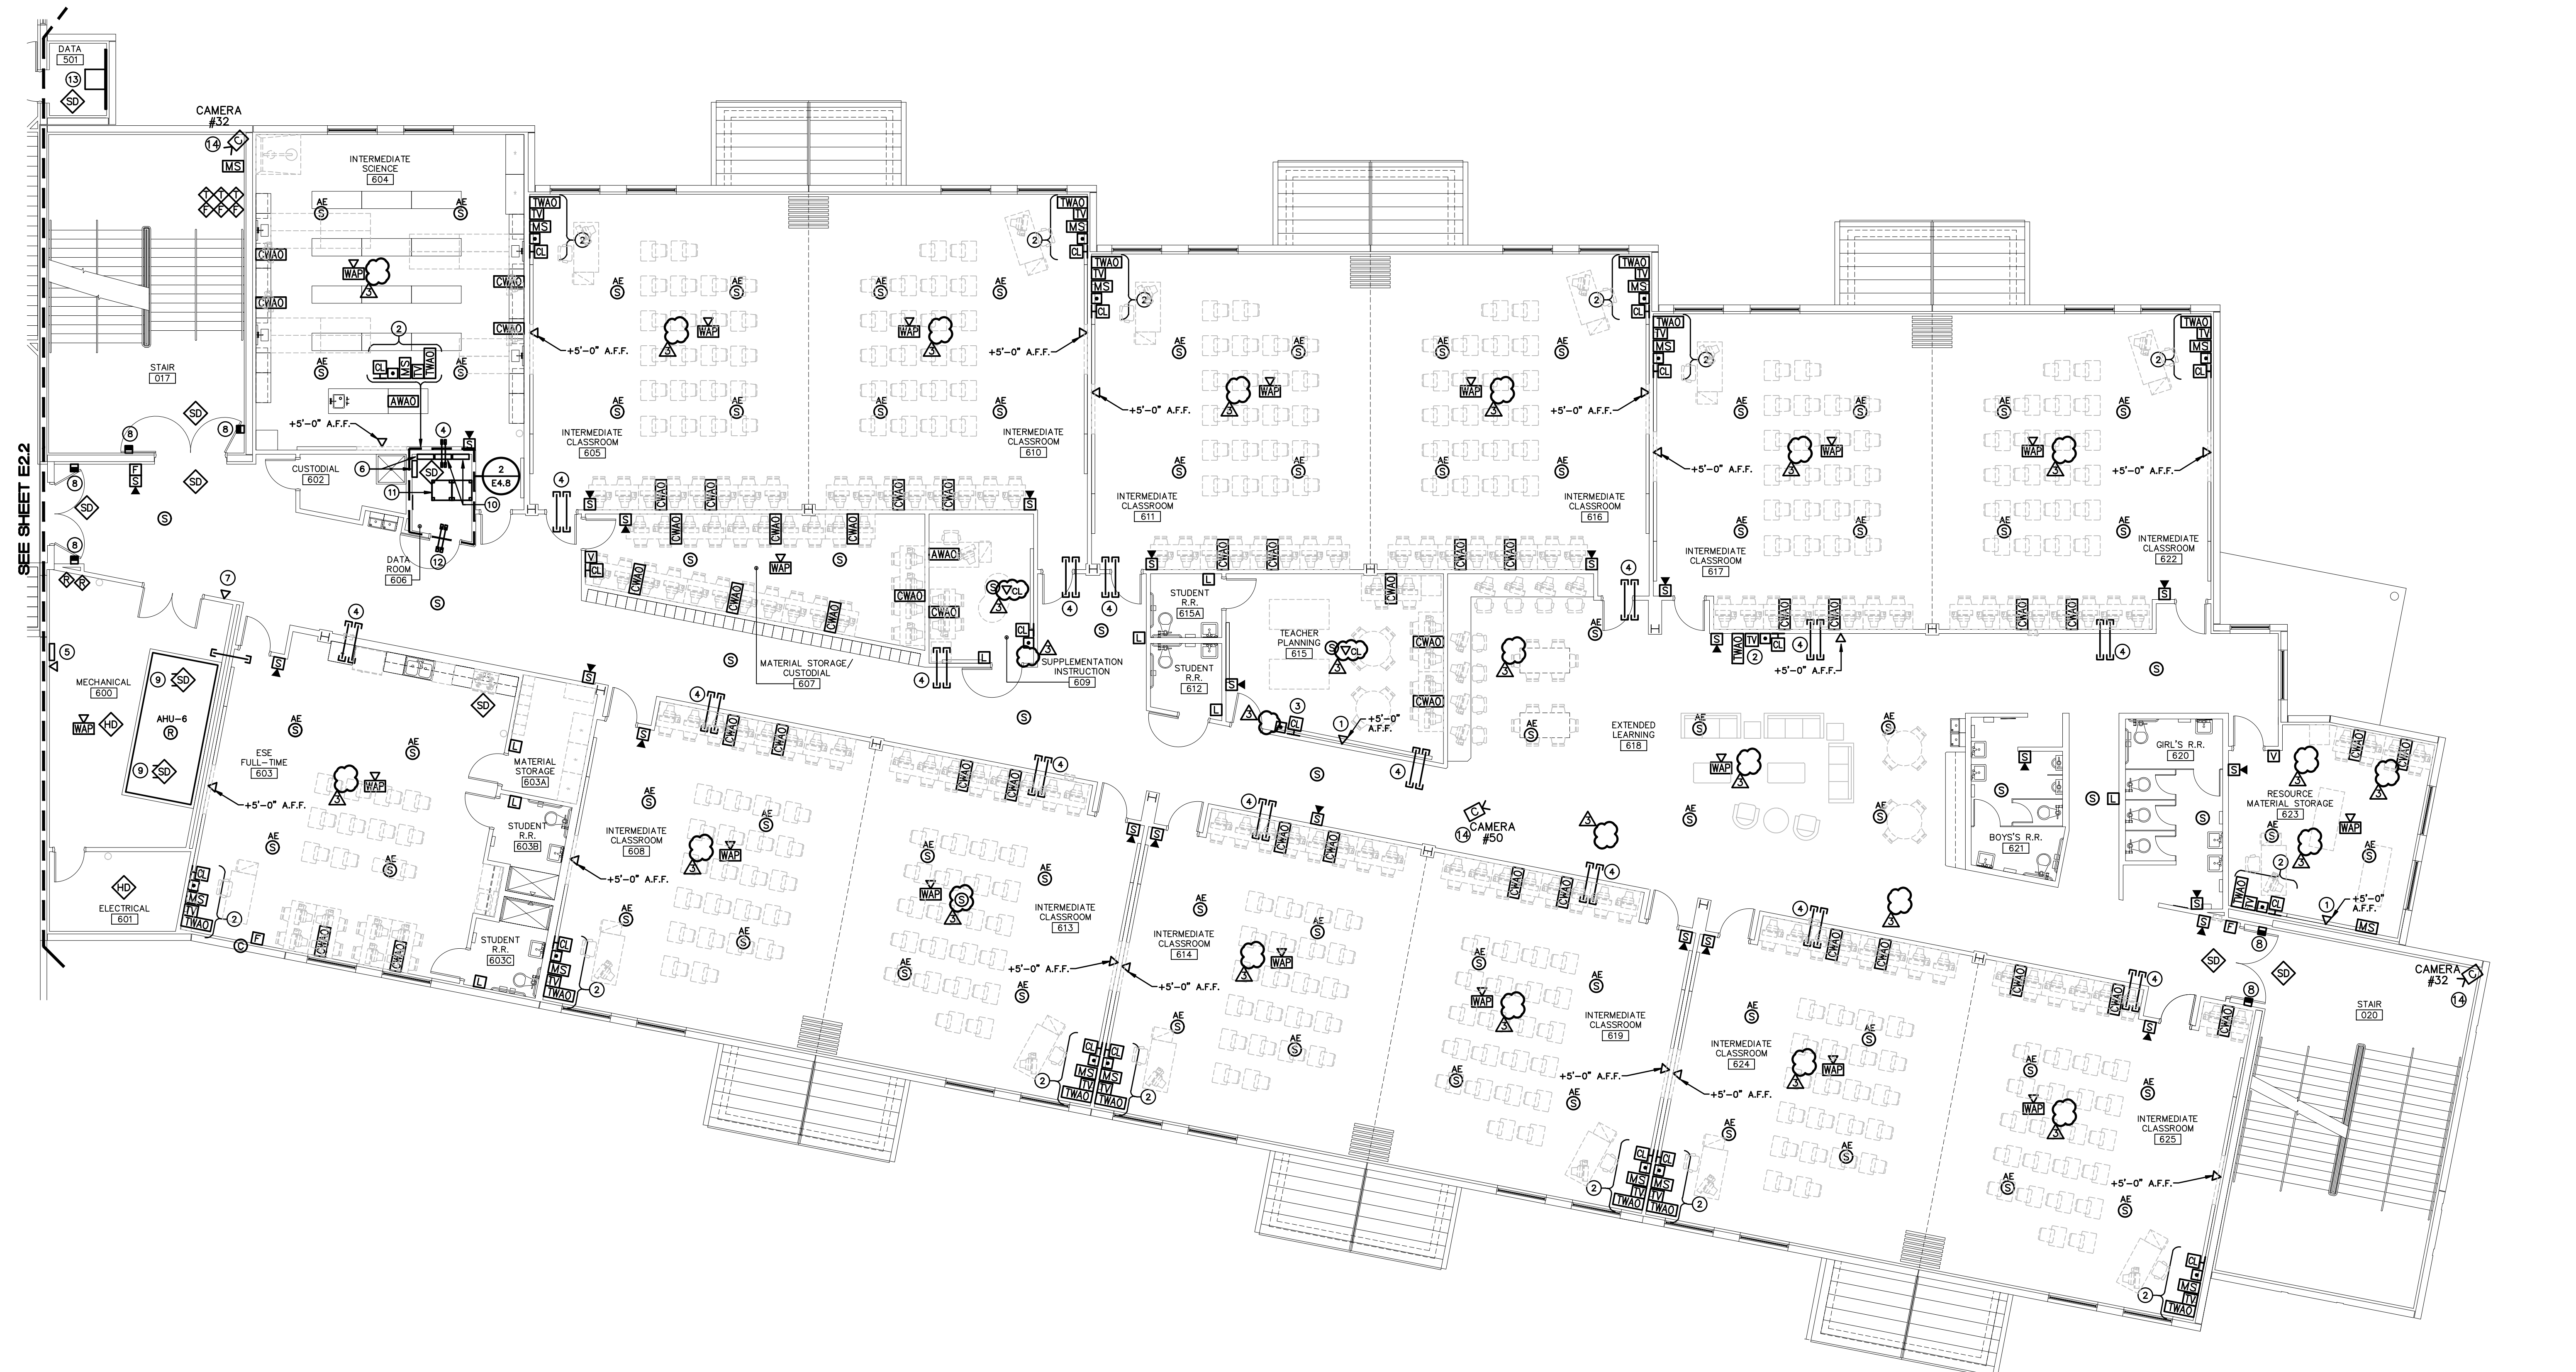


GENERAL NOTE

VERIFY WORK AREA OUTLET
CONFIGURATION WITH OWNER PRIOR TO
ROUGH-IN. SEE SHEET E7.3 FOR
DETAILS.

SYSTEM PLAN NOTES


- 1 MOUNTING BRACKET FOR PROJECTOR. SEE DETAIL 1/E7.3.
- 2 SEE DETAIL 1/E7.3 FOR SYSTEM OUTLETS MEDIA SHELF AND AT THE TEACHER'S STATION. CONTRACTOR SHALL PROVIDE THE EXACT LOCATION OF ALL CASEWORKER PIPES TO ROUGH-IN OF ALL DEVICES.
- 3 BUILDING CLOCK/ TRANSMITTER.
- 4 2" CONDUIT SLEEVES, QUANTITY AS SHOWN, FOR WIRING FROM ROOM TO CABLE.
- 5 EMS CONTROL PANEL.
- 6 FIRE ALARM CONTROL PANEL AND TERMINAL CABINET.
- 7 DATA OUTLET FOR MONITOR MOUNTED 24" ABOVE CEILING HEIGHT. VERIFY EXACT MOUNTING LOCATION WITH OWNER PRIOR TO ROUGH-IN.
- 8 COORDINATE DOOR HOLLOW LOCATION WITH DOOR SWING PRIOR TO ROUGH-IN. WHERE CATCH PLATE EXTENSIONS ARE REQUIRED, USE MANUFACTURER SPECIFIC UL LISTED PARTS. ALL THREAD OR CHAINLINK TYPE DOOR CLOSING EXTENSIONS OVER 8 INCHES ARE NOT PERMITTED.
- 9 NFPA REQUIREMENTS STATE THAT SAMPLING TUBES MUST EXTEND AT LEAST TWO-THIRDS OF THE WAY INTO ROOMS AND THOSE THAT ARE GREATER THAN 36 INCHES LONG MUST BE SUPPORTED AT BOTH ENDS. TO MEET THIS REQUIREMENT, DRILL A HOLE ON OPPOSITE SIDE OF THE DUCT. EXTEND THE SAMPLING TUBE THROUGH THE HOLE. CUT OFF THE EXCESS TUBING AND SEAL THE OPENING AROUND THE TUBE WITH AN APPROVED SEALANT.
- 10 INTRUSION DETECTION CONTROL PANEL AND TERMINAL CABINET.
- 11 FLOOR MOUNTED I.T. DATA RACK.
- 12 2-3" CONDUIT SLEEVES.
- 13 FLOOR MOUNTED I.T. DATA RACK AND BACKBOARD.
- 14 VERIFY MOUNTING HEIGHT AND LOCATION WITH OWNER PRIOR TO ROUGH-IN.

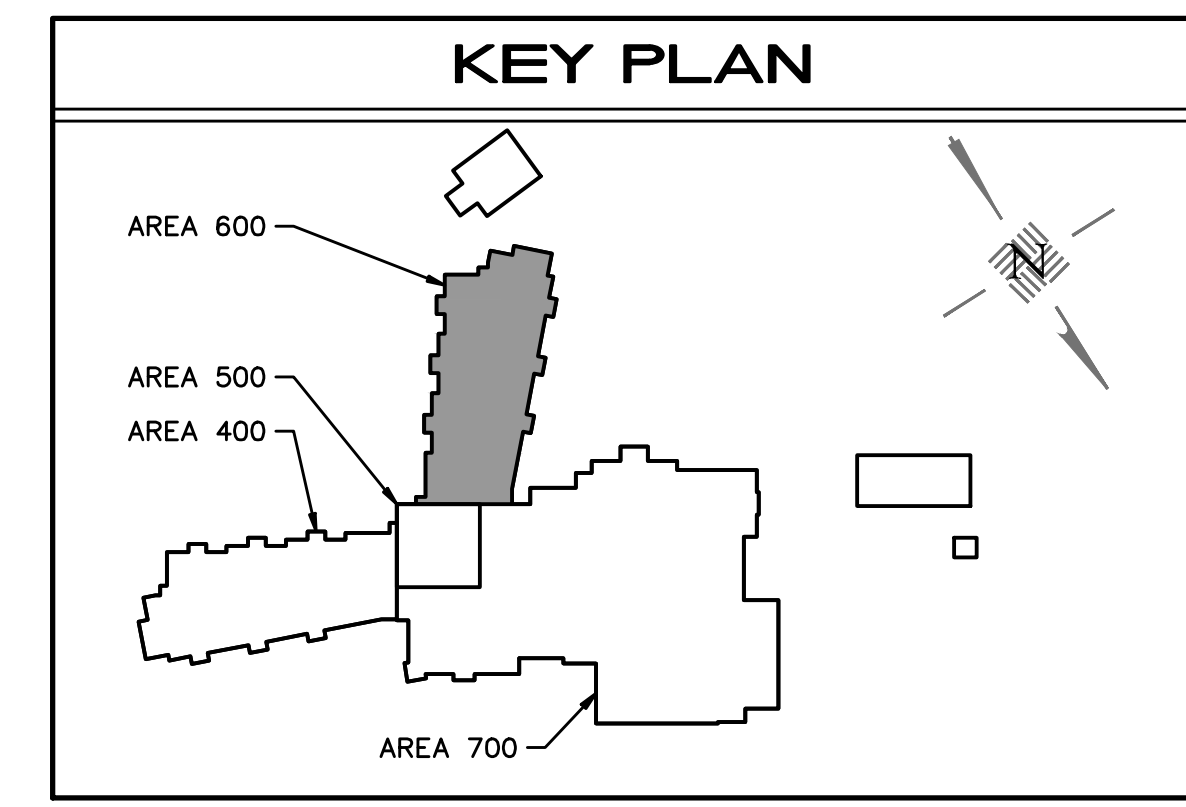

1 SECOND FLOOR AREA 600 SYSTEMS PLAN


SCALE: 1/8"=1'-0"

This information is intended to be used in conjunction with the information contained herein, and shall not be used in any other manner. The user hereby acknowledges that the user shall be responsible for any and all consequences of any use of the information contained herein, and shall not be held responsible for any and all consequences of any use of the information contained herein.

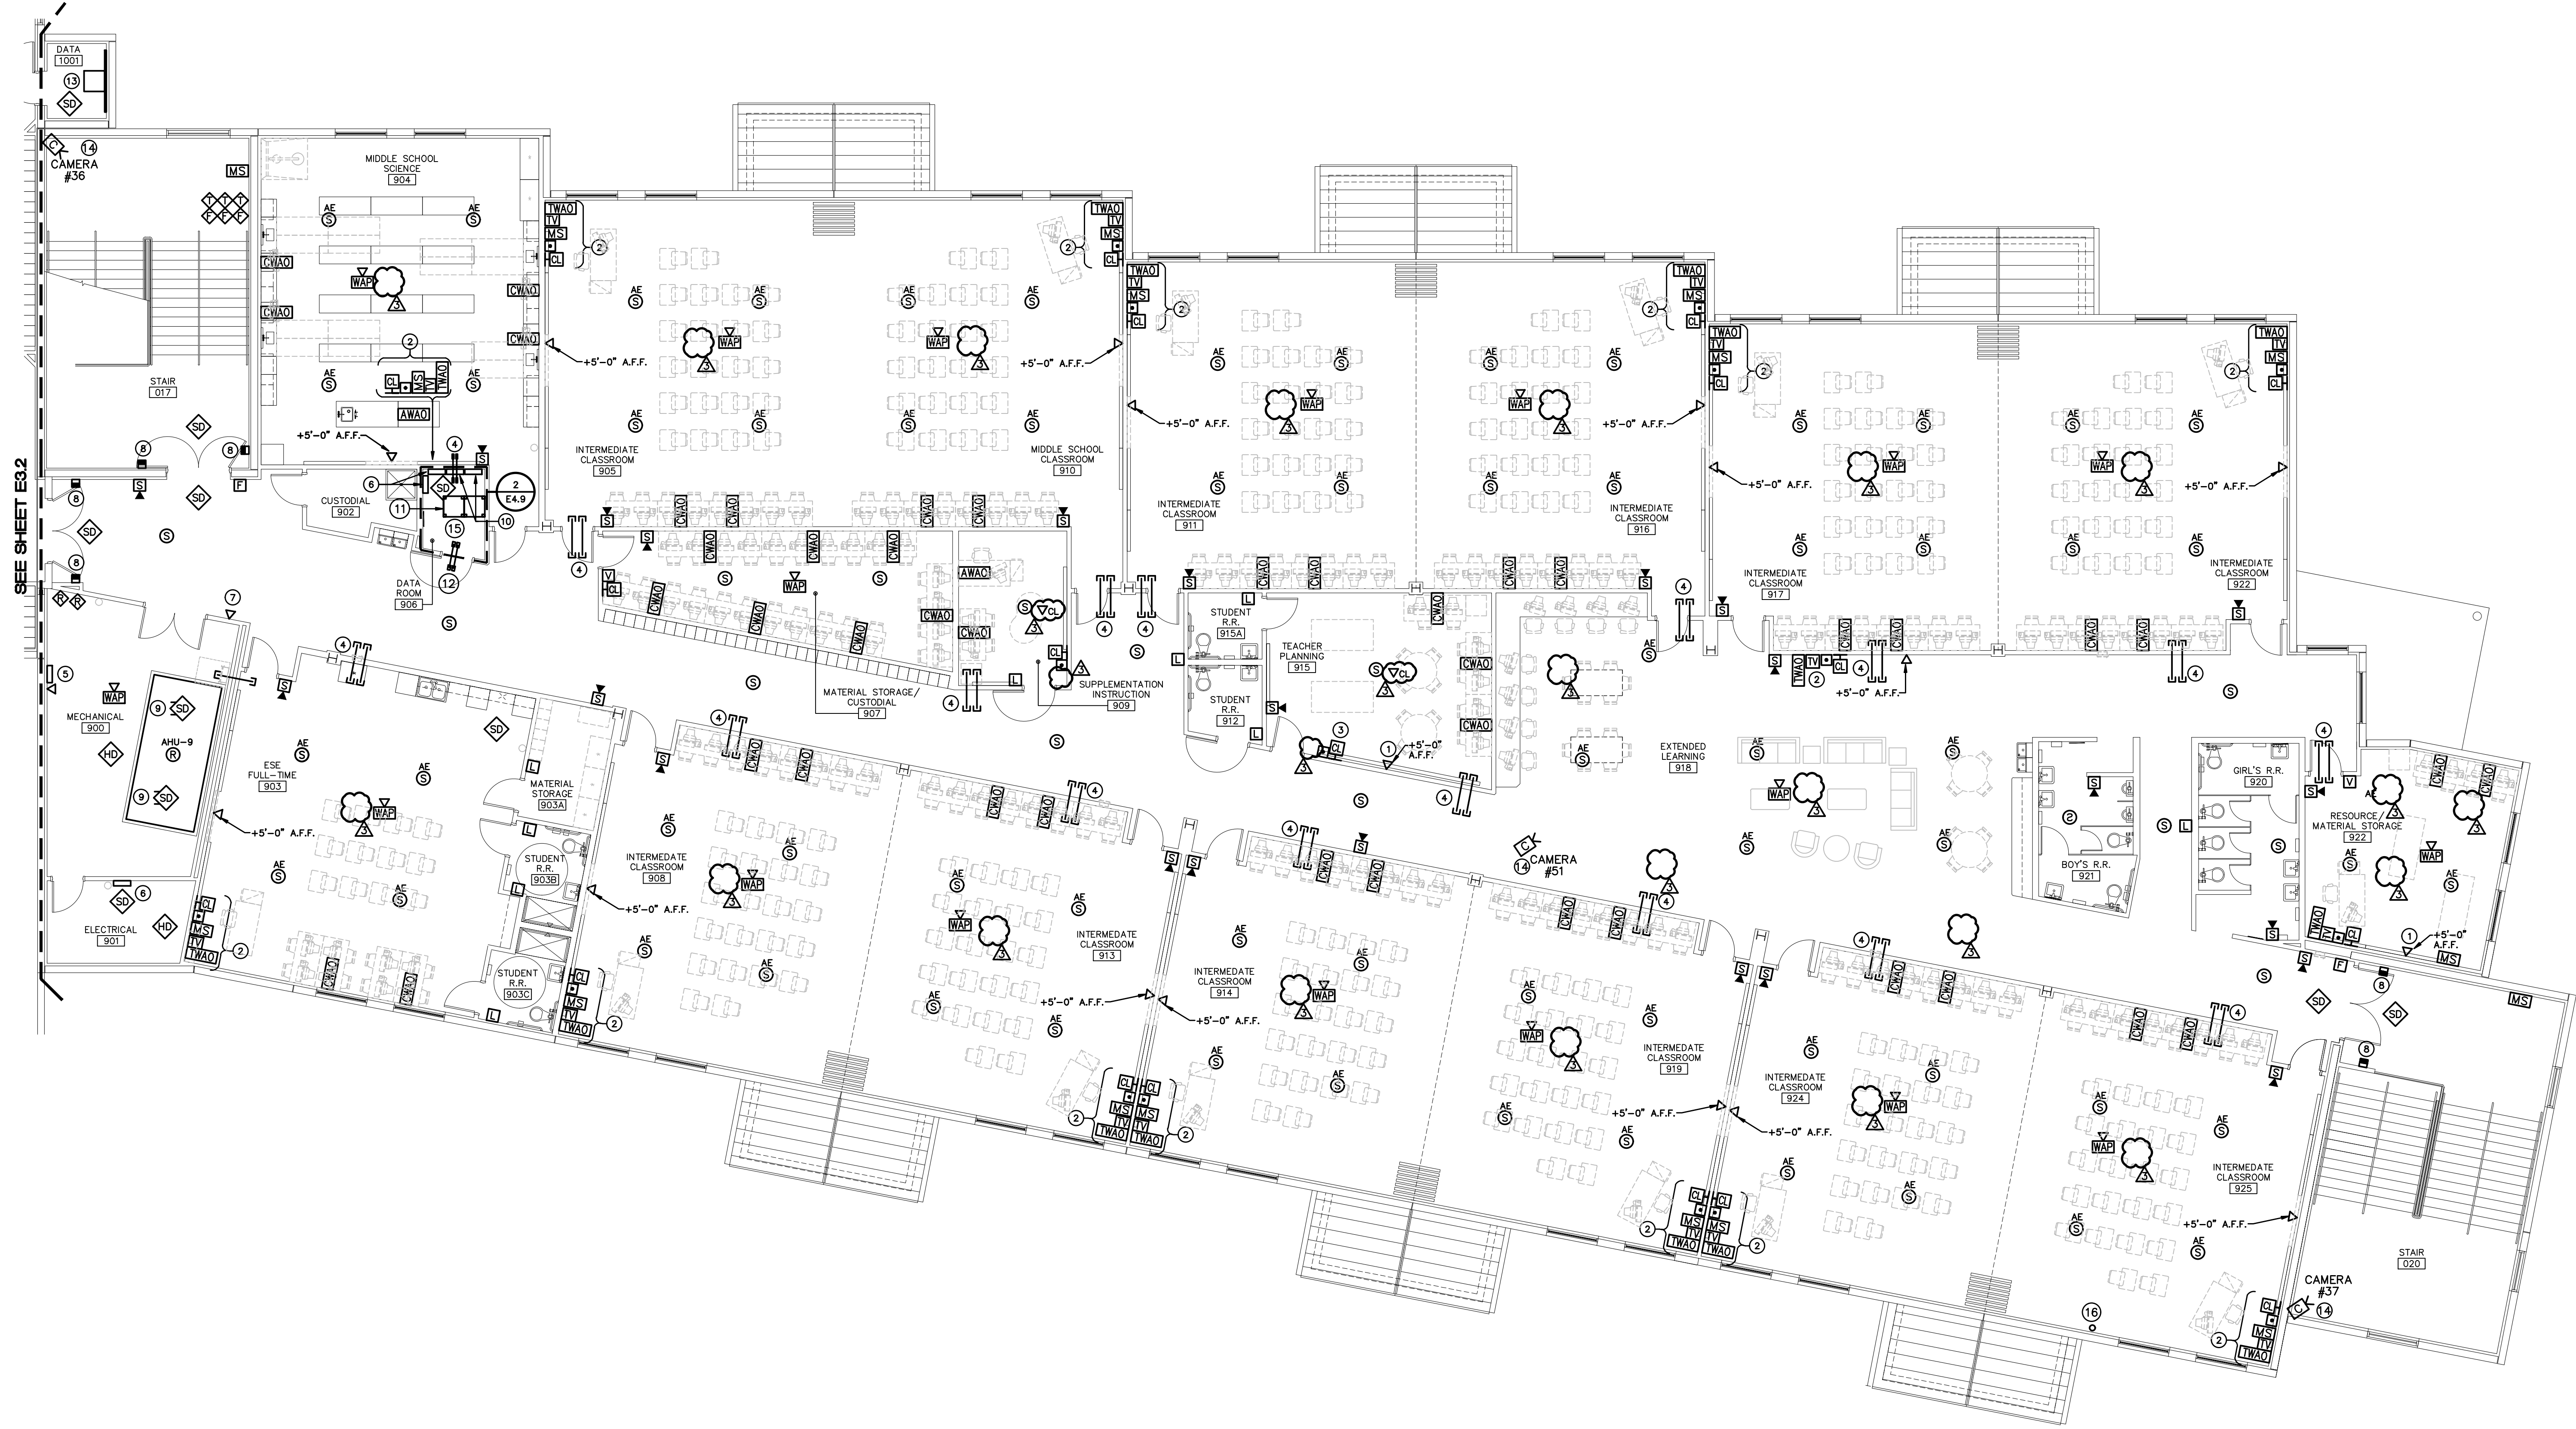

1 THIRD FLOOR AREA 900 SYSTEMS PLAN 15

SCALE: 1/8"=1'-0"

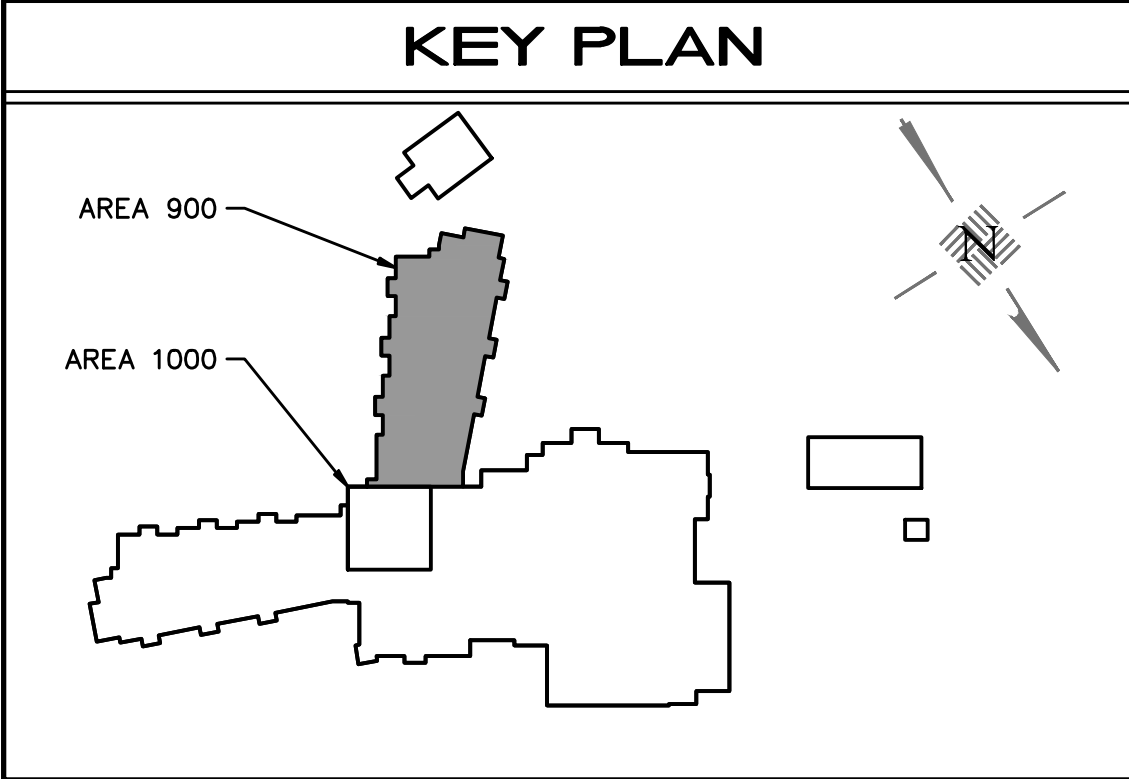

GENERAL NOTE
VERIFY WORK AREA OUTLET CONFIGURATION WITH OWNER PRIOR TO ROUGH-IN. SEE SHEET E7.3 FOR DETAILS.


SYSTEM PLAN NOTES

- 1 MOUNTING BRACKET FOR PROJECTOR. SEE DETAIL 1/E7.3.
- 2 SEE DETAIL 1/E7.3 FOR SYSTEM OUTLETS MEDIA SHELF AND AT THE TEACHER'S STATION. CONTRACTOR SHALL VERIFY THE EXACT LOCATION OF ALL CASEWORK PRIOR TO ROUGH-IN OF ALL DEVICES.
- 3 BUILDING CLOCK/ TRANSMITTER.
- 4 2" CONDUIT SLEEVES, QUANTITY AS SHOWN, FOR WIRING FROM ROOM TO CABLETRAY.
- 5 EMS CONTROL PANEL.
- 6 FIRE ALARM CONTROL PANEL AND TERMINAL CABINET.
- 7 DATA OUTLET FOR MONITOR MOUNTED 24" BELOW CEILING HEIGHT. VERIFY EXACT MOUNTING LOCATION WITH OWNER PRIOR TO ROUGH-IN.
- 8 COORDINATE DOOR HOLDER LOCATION WITH DOOR SWING PRIOR TO ROUGH-IN. WHERE CATCH PLATE EXTENSIONS ARE REQUIRED, USE MANUFACTURER SPECIFIC UL LISTED PARTS. ALL-THREAD OR CHAINLINK TYPE EXTENSIONS AND EXTENSIONS OVER 8 INCHES ARE NOT PERMITTED.
- 9 NFPA REQUIREMENTS STATE THAT SAMPLING TUBES MUST EXTEND AT LEAST TWO-THIRDS OF THE WAY INTO THE DUCT AND THOSE THAT ARE GREATER THAN 36 INCHES LONG MUST BE SUPPORTED AT BOTH ENDS. TO MEET THIS REQUIREMENT, DRILL A HOLE ON THE OPPOSITE SIDE OF THE DUCT. EXTEND THE SAMPLING TUBE THROUGH THE HOLE. CUT OFF THE EXCESS SAMPLING TUBE AND SEAL THE OPENING AROUND THE TUBE WITH AN APPROVED SEALANT.
- 10 INTRUSION DETECTION CONTROL PANEL AND TERMINAL CABINET.
- 11 FLOOR MOUNTED I.T. DATA RACK.
- 12 2-3" CONDUIT SLEEVES.
- 13 FLOOR MOUNTED I.T. DATA RACK AND BACKBOARD.
- 14 VERIFY MOUNTING HEIGHT AND LOCATION WITH OWNER PRIOR TO ROUGH-IN.
- 15 PROVIDE AND INSTALL (2) 2" PIPES THROUGH DATA ROOM ROOF FOR ANTENNAS, 800MHZ AND SCHOOL RADIO.
- 16 PROVIDE AND INSTALL (1) 2" C FOR CABLE TV ANTENNA TO BE MOUNTED ON TILT WALL.

Revisions		
No.	Date	Note
3	11/28/22	ADDENDUM 3


TO THE BEST OF MY KNOWLEDGE, THE PLANS AND SPECIFICATIONS COMPLY WITH THE MINIMUM BUILDING CODES.

This information is intended solely for the use of the owner, architect, engineer, contractor, and other parties involved in the project. It is not to be used for any other purpose. The user hereby acknowledges that the information contained herein, and without full certification as to the same, may be used for any other purpose. The user hereby acknowledges that the information contained herein, and without full certification as to the same, may be used for any other purpose.

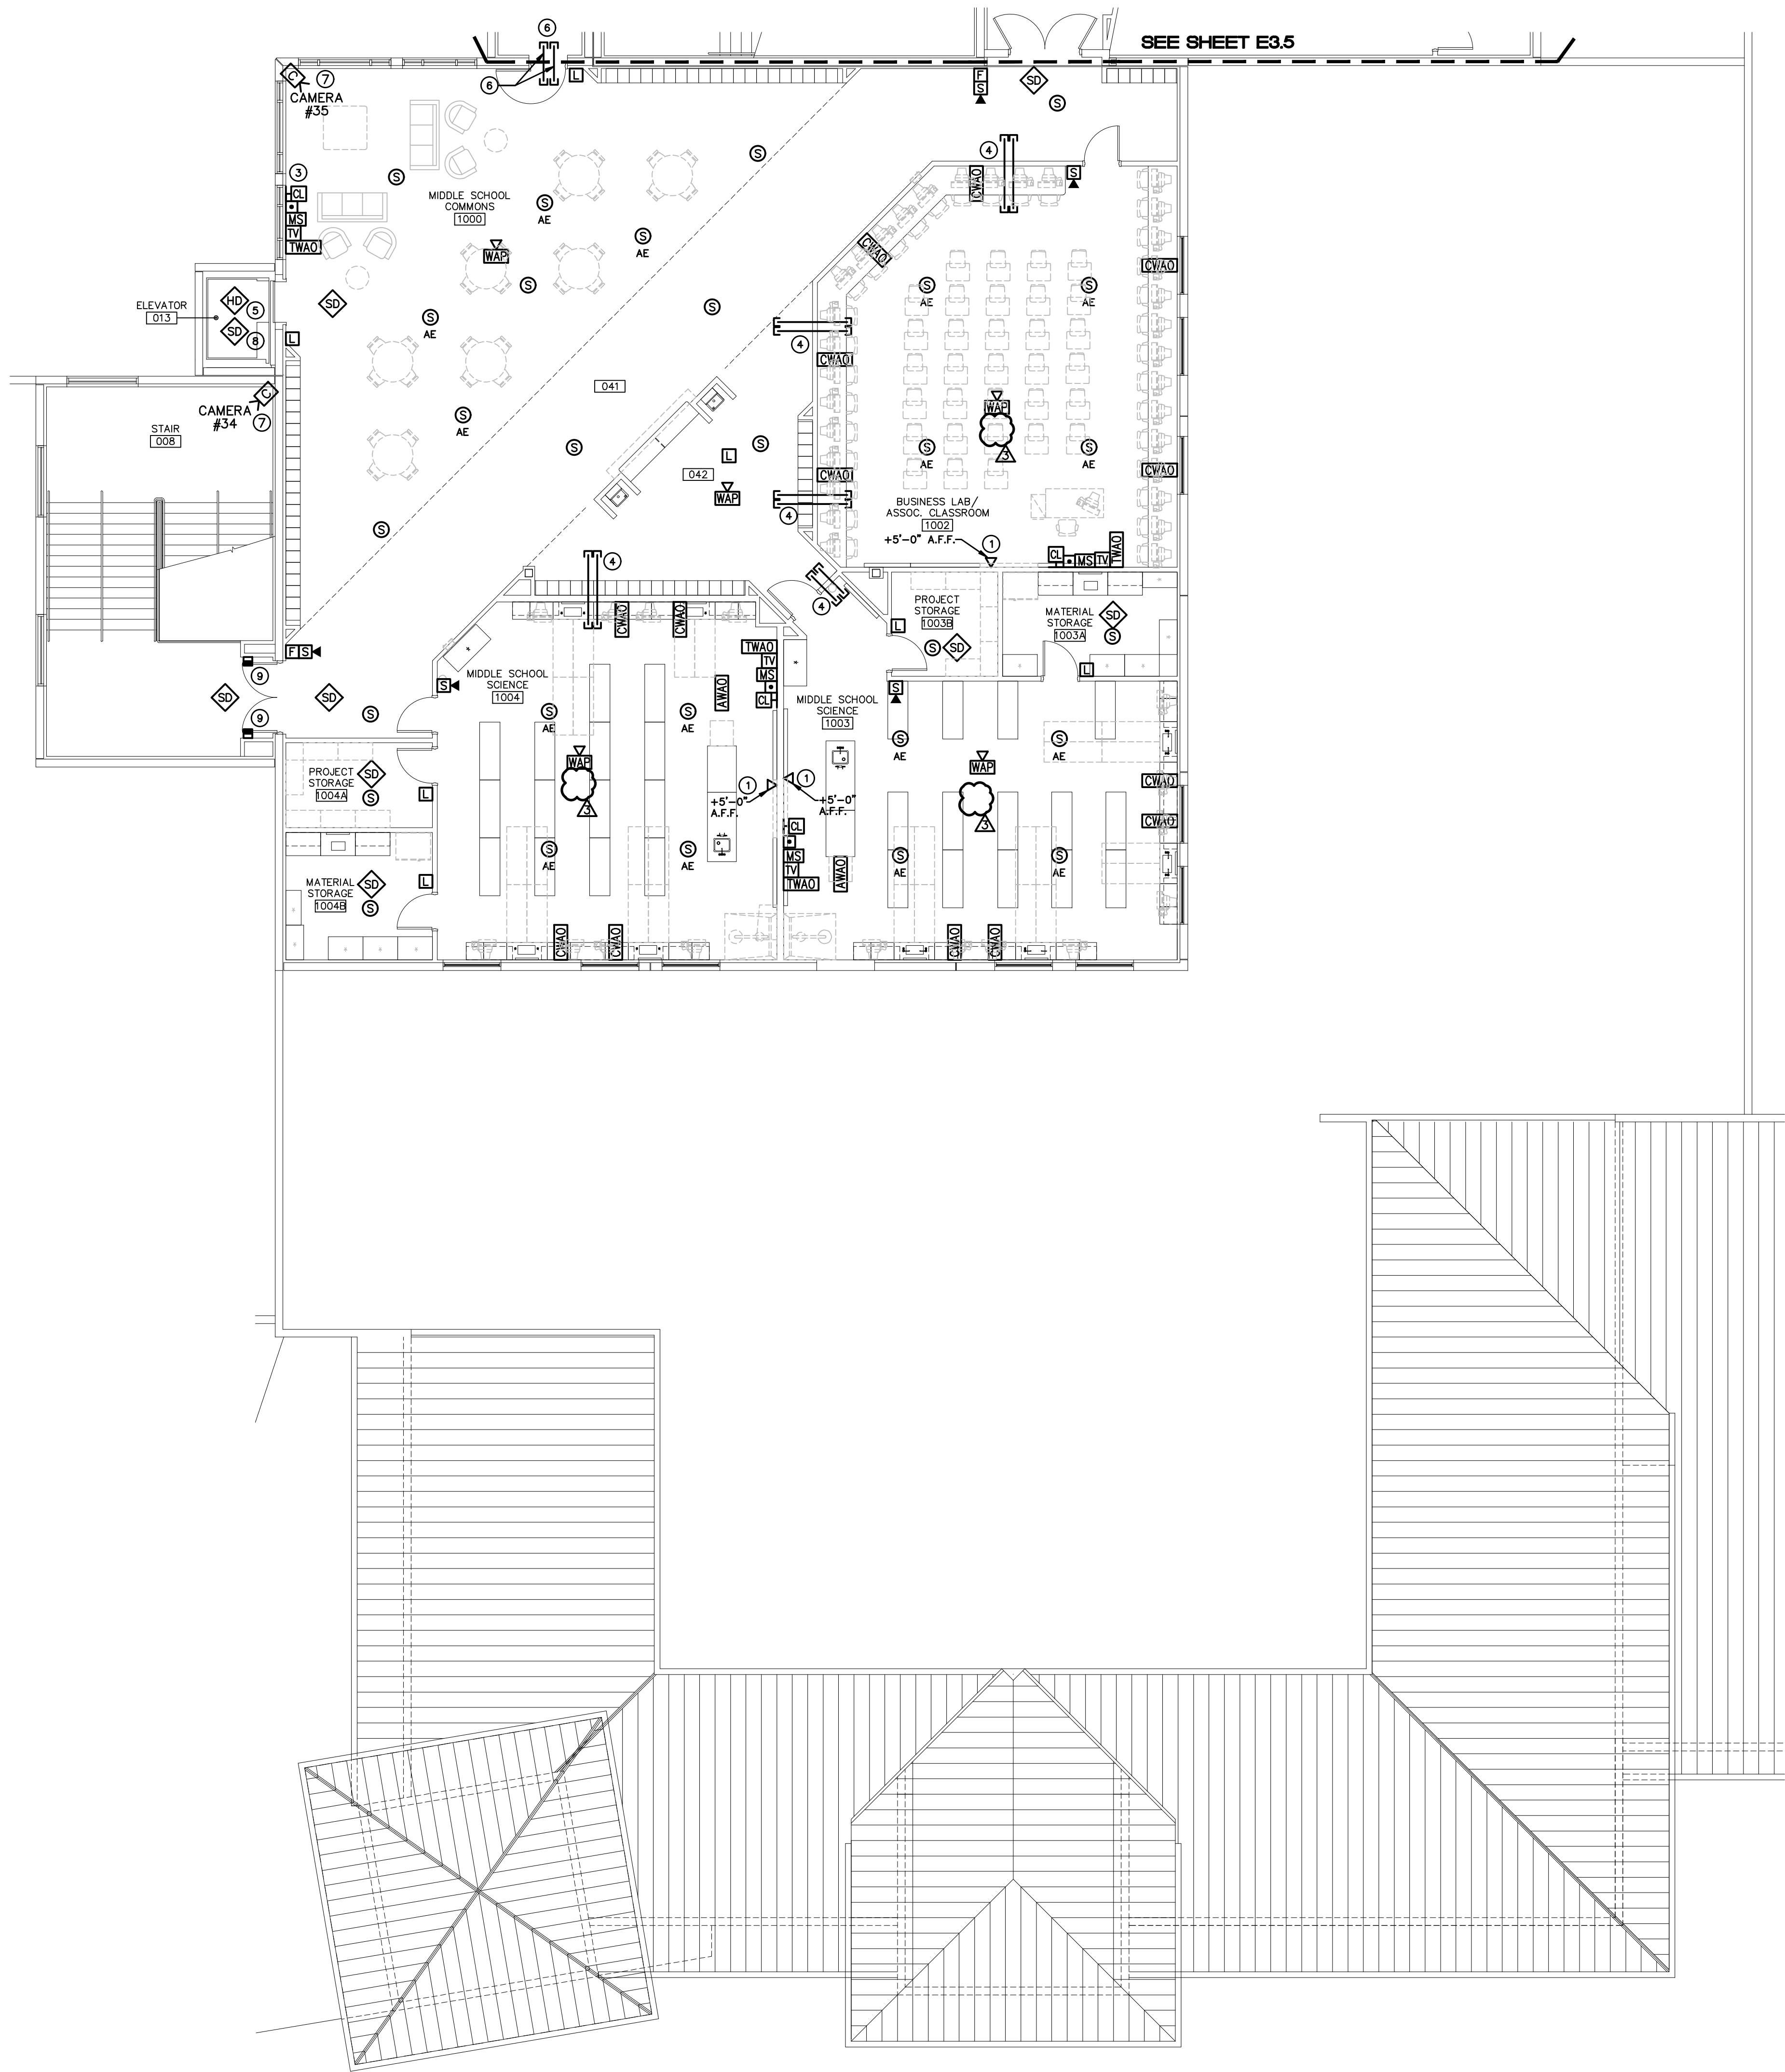

1
E3.6
THIRD FLOOR AREA 1000 SYSTEMS PLAN

SCALE: 1/8"=1'-0"

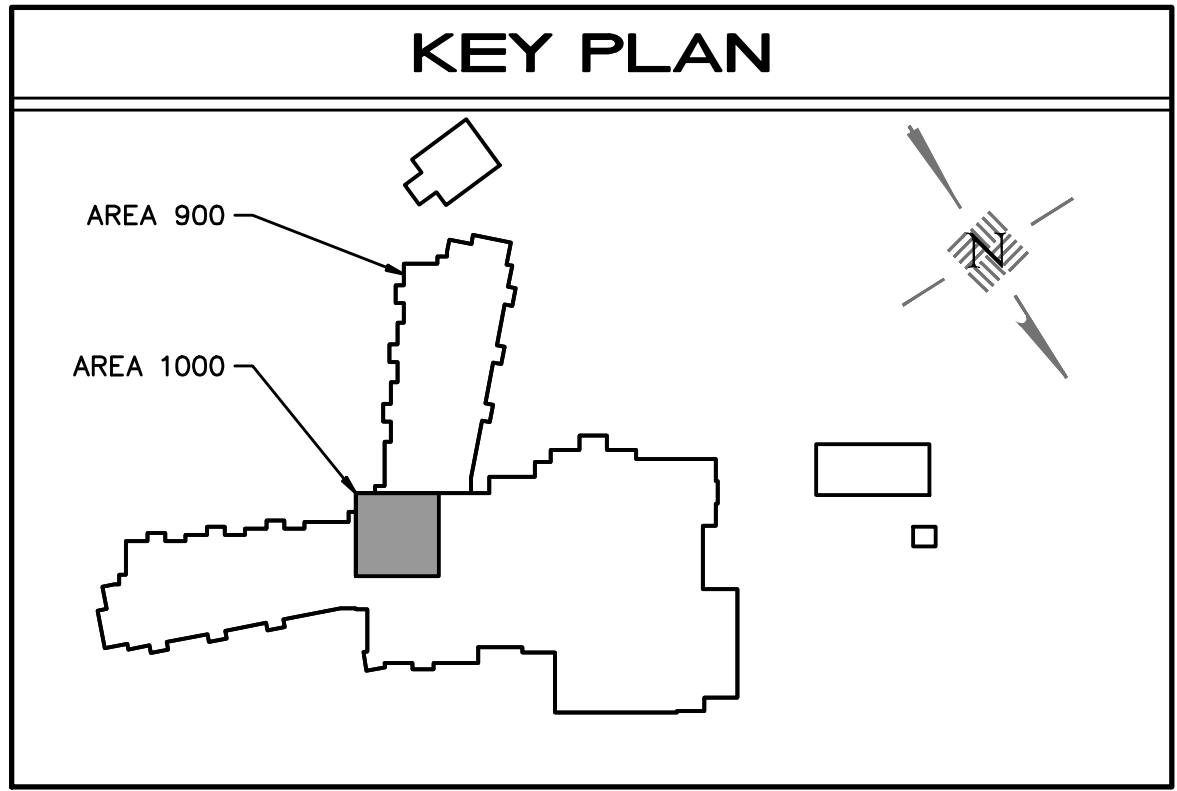

GENERAL NOTE

VERIFY WORK AREA OUTLET CONFIGURATION WITH OWNER PRIOR TO ROUGH-IN. SEE SHEET E7.3 FOR DETAILS.

SYSTEM PLAN NOTES

- DATA OUTLET FOR PROJECTOR. SEE DETAIL 1/E7.3.
- SEE DETAIL 1/E7.3 FOR SYSTEM OUTLETS MEDIA SHELF AND AT THE TEACHER'S STATION. CONTRACTOR SHALL VERIFY THE EXACT LOCATION OF ALL CASEWORK PRIOR TO ROUGH-IN OF ALL DEVICES.
- BUILDING CLOCK/ TRANSMITTER.
- 2" CONDUIT SLEEVES, QUANTITY AS SHOWN, FOR WIRING FROM ROOM TO CABLETRAY.
- HEAT DETECTOR TIED TO ELEVATOR SHUNT TRIP.
- 2-3" CONDUIT SLEEVES TO DATA ROOM 1001.
- VERIFY MOUNTING HEIGHT AND LOCATION WITH OWNER PRIOR TO ROUGH-IN.
- COORDINATE SMOKE DETECTOR REQUIREMENTS IN ELEVATOR SHAFT WITH LOCAL AHJ AND STATE ELEVATOR INSPECTOR.
- COORDINATE DOOR HOLDER LOCATION WITH DOOR SWING PRIOR TO ROUGH-IN. WHERE CATCH PLATE EXTENSIONS ARE REQUIRED, USE MANUFACTURER SPECIFIC UL LISTED PARTS. ALLTHREAD OR CHAINLINK TYPE EXTENSIONS AND EXTENSIONS OVER 8 INCHES ARE NOT PERMITTED.

Revisions		
No.	Date	Note
3	11/28/22	ADDENDUM 3

TO THE BEST OF MY KNOWLEDGE, THE PLANS AND SPECIFICATIONS COMPLY WITH THE MINIMUM BUILDING CODES.